



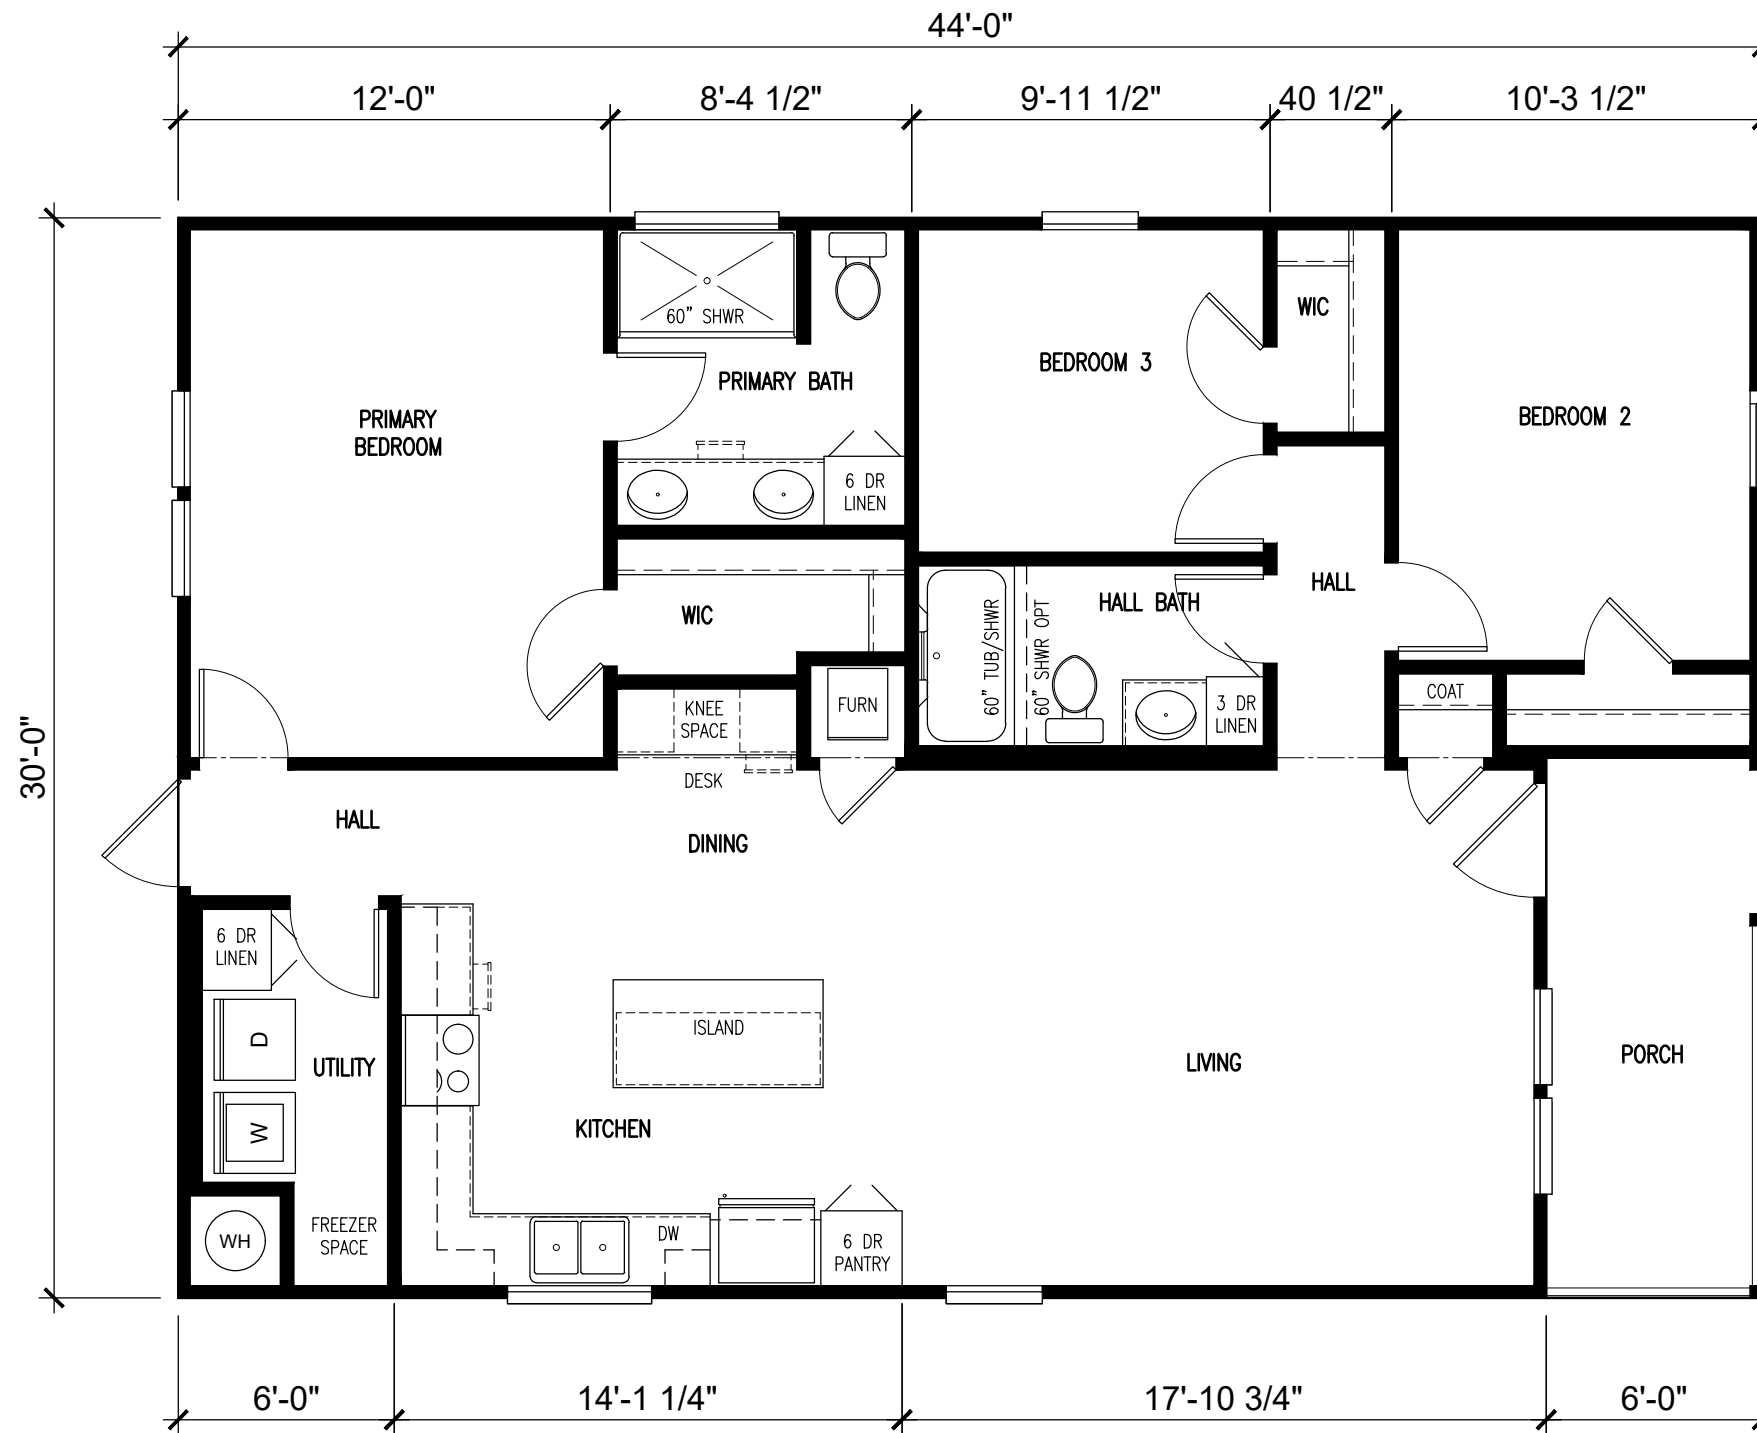

MODEL: 32443A

NOTE:
• EXTERIOR DIMENSIONS ARE TO EDGE OF EXTERIOR WALL FRAMING.
• INTERIOR DIMENSIONS ARE TO CENTER OF WALLS

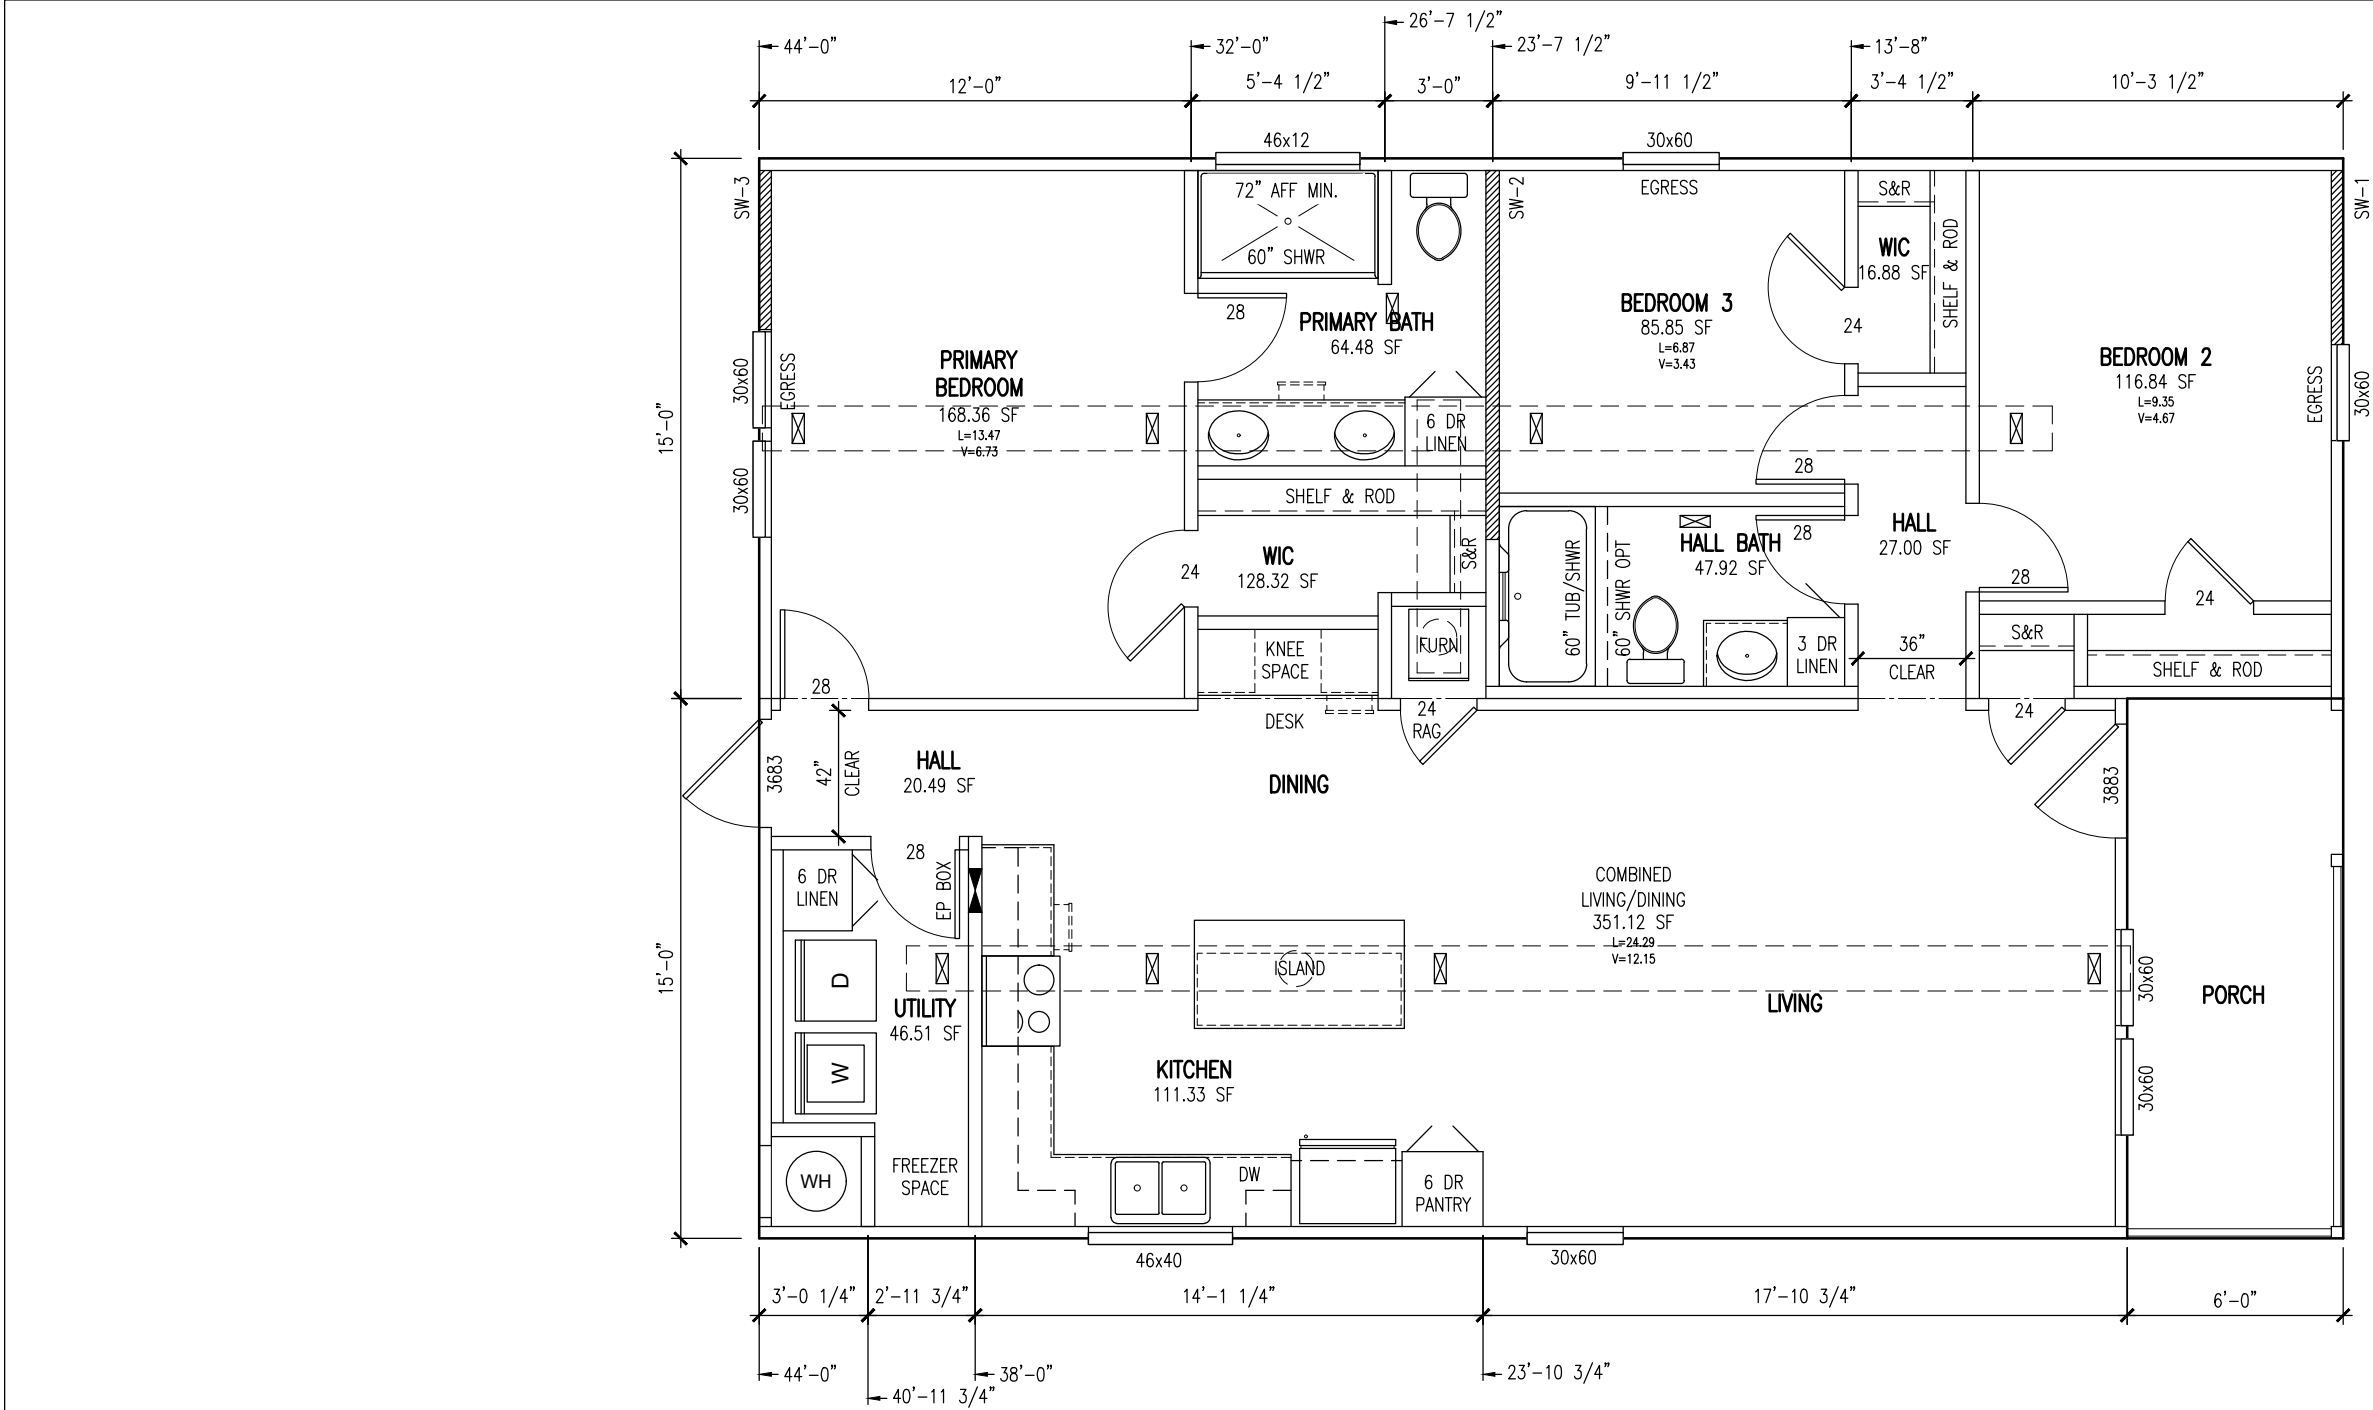

96" SIDEWALL HEIGHT

* WITH FULL DEPTH CROSS MEMBER

SHEARWALL DATA WIND ZONE 1			
SHEARWALL NUMBER	1	2	3
TRIBUTARY SPAN	11'-10"	22'-0"	10'-3"
LENGTH MINIMUM	58"	123"	53"
PLF	150	150	150
NUMBER OF JOISTS	*1	1	2
NUMBER OF SCREWS	1	1	1
DIAPHRAGM	ANY APPROVED		


MODEL:	MARATHON – 32443A
DWG:	FP-32443A.1.1

DATE:	06/25/2026
SCALE:	3/16" = 1'-0"

TITLE:		APPROVAL FLOOR PLAN WZ1	
REF #	DESCRIPTION	DATE	REVISED BY:
-	-	-	-

- NOTES:
1. LIGHT AND VENT BASED ON KINRO 9700 & 9750 SERIES WINDOWS.
2. REFERENCE SHEARWALL CHART SW-12.1 FOR JOIST & FASTENERS.
3. RETURN AIR GRILL REQUIRED ON ALL ROOMS GREATER THAN 170 SF IF CLOSED OFF WITH AN UNDERCUT 28" DOOR. REFER TO DS-2.1
4. TOTAL MAX. WINDOW ROUGH OPENING = 107 SF. THERMOPANE (INSULATED) GLASS REQUIRED FOR ALL THERMAL ZONES.
5. STANDARD DOOR ROUGH OPENING = 43 SF.
6. MAXIMUM TRAVEL FROM THE PRIMARY BEDROOM TO NEAREST EXIT = 2'-4", BEDROOM 2 = 10'-8", AND BEDROOM 3 = 13'-10".
7. REFERENCE COLUMN STUD CAPACITY CHART CS-2 FOR COLUMN STUD QUANTITIES.



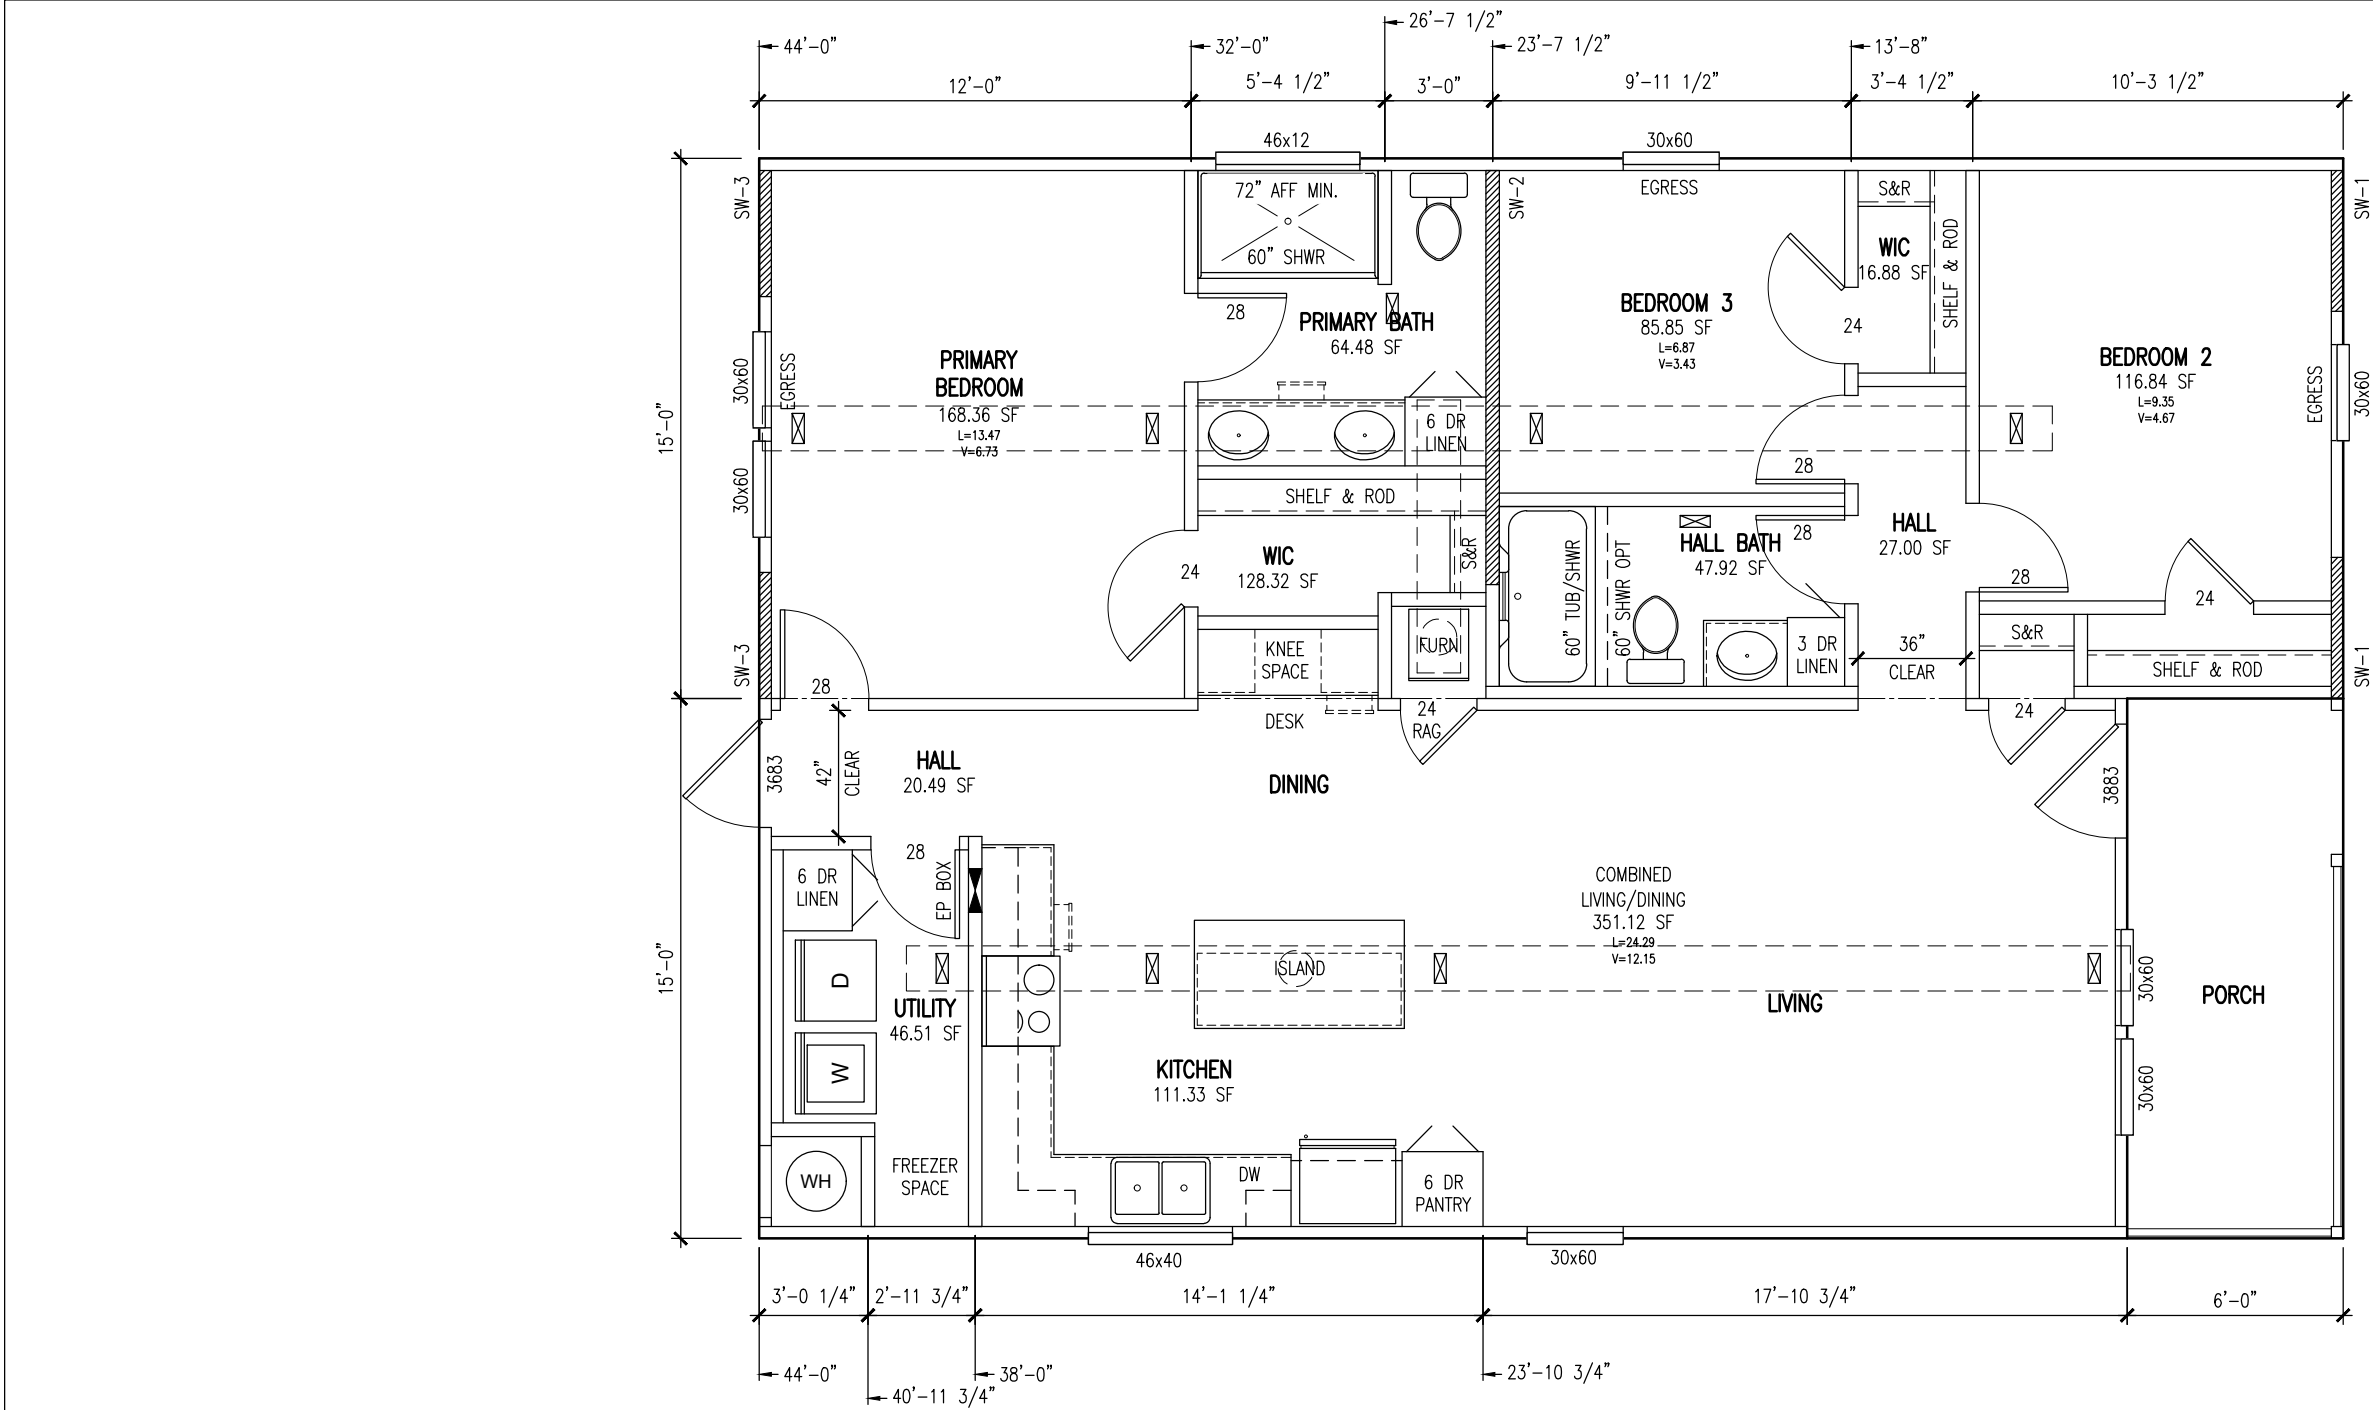

96" SIDEWALL HEIGHT
* WITH FULL DEPTH CROSS MEMBER

SHEARWALL DATA WIND ZONE 2			
SHEARWALL NUMBER	1	2	3
TRIBUTARY SPAN	11'-10"	22'-0"	10'-3"
LENGTH MINIMUM	47"+47"	138"	42"+42"
PLF	240	300	240
NUMBER OF JOISTS	*1	3	3
NUMBER OF SCREWS	2	2	2
DIAPHRAGM	ANY APPROVED		

MODEL:	MARATHON – 32443A
DWG:	FP-32443A.1.2

DATE:	06/25/2026
SCALE:	3/16" = 1'-0"

TITLE:		APPROVAL FLOOR PLAN WZ2	
REF #	DESCRIPTION	DATE	REVISED BY:
-	-	-	-

- NOTES:
1. LIGHT AND VENT BASED ON KINRO 9700 & 9750 SERIES WINDOWS.

2. REFERENCE SHEARWALL CHART SW-12.4 FOR JOIST & FASTENERS.

3. RETURN AIR GRILL REQUIRED ON ALL ROOMS GREATER THAN 170 SF IF CLOSED OFF WITH AN UNDERCUT 28" DOOR. REFER TO DS-2.1


4. TOTAL MAX. WINDOW ROUGH OPENING = 107 SF. THERMOPANE (INSULATED) GLASS REQUIRED FOR ALL THERMAL ZONES.

5. STANDARD DOOR ROUGH OPENING = 43 SF.

6. MAXIMUM TRAVEL FROM THE PRIMARY BEDROOM TO NEAREST EXIT = 2'-4", BEDROOM 2 = 10'-8", AND BEDROOM 3 = 13'-10".

7. REFERENCE COLUMN STUD CAPACITY CHART CS-2 FOR COLUMN STUD QUANTITIES.



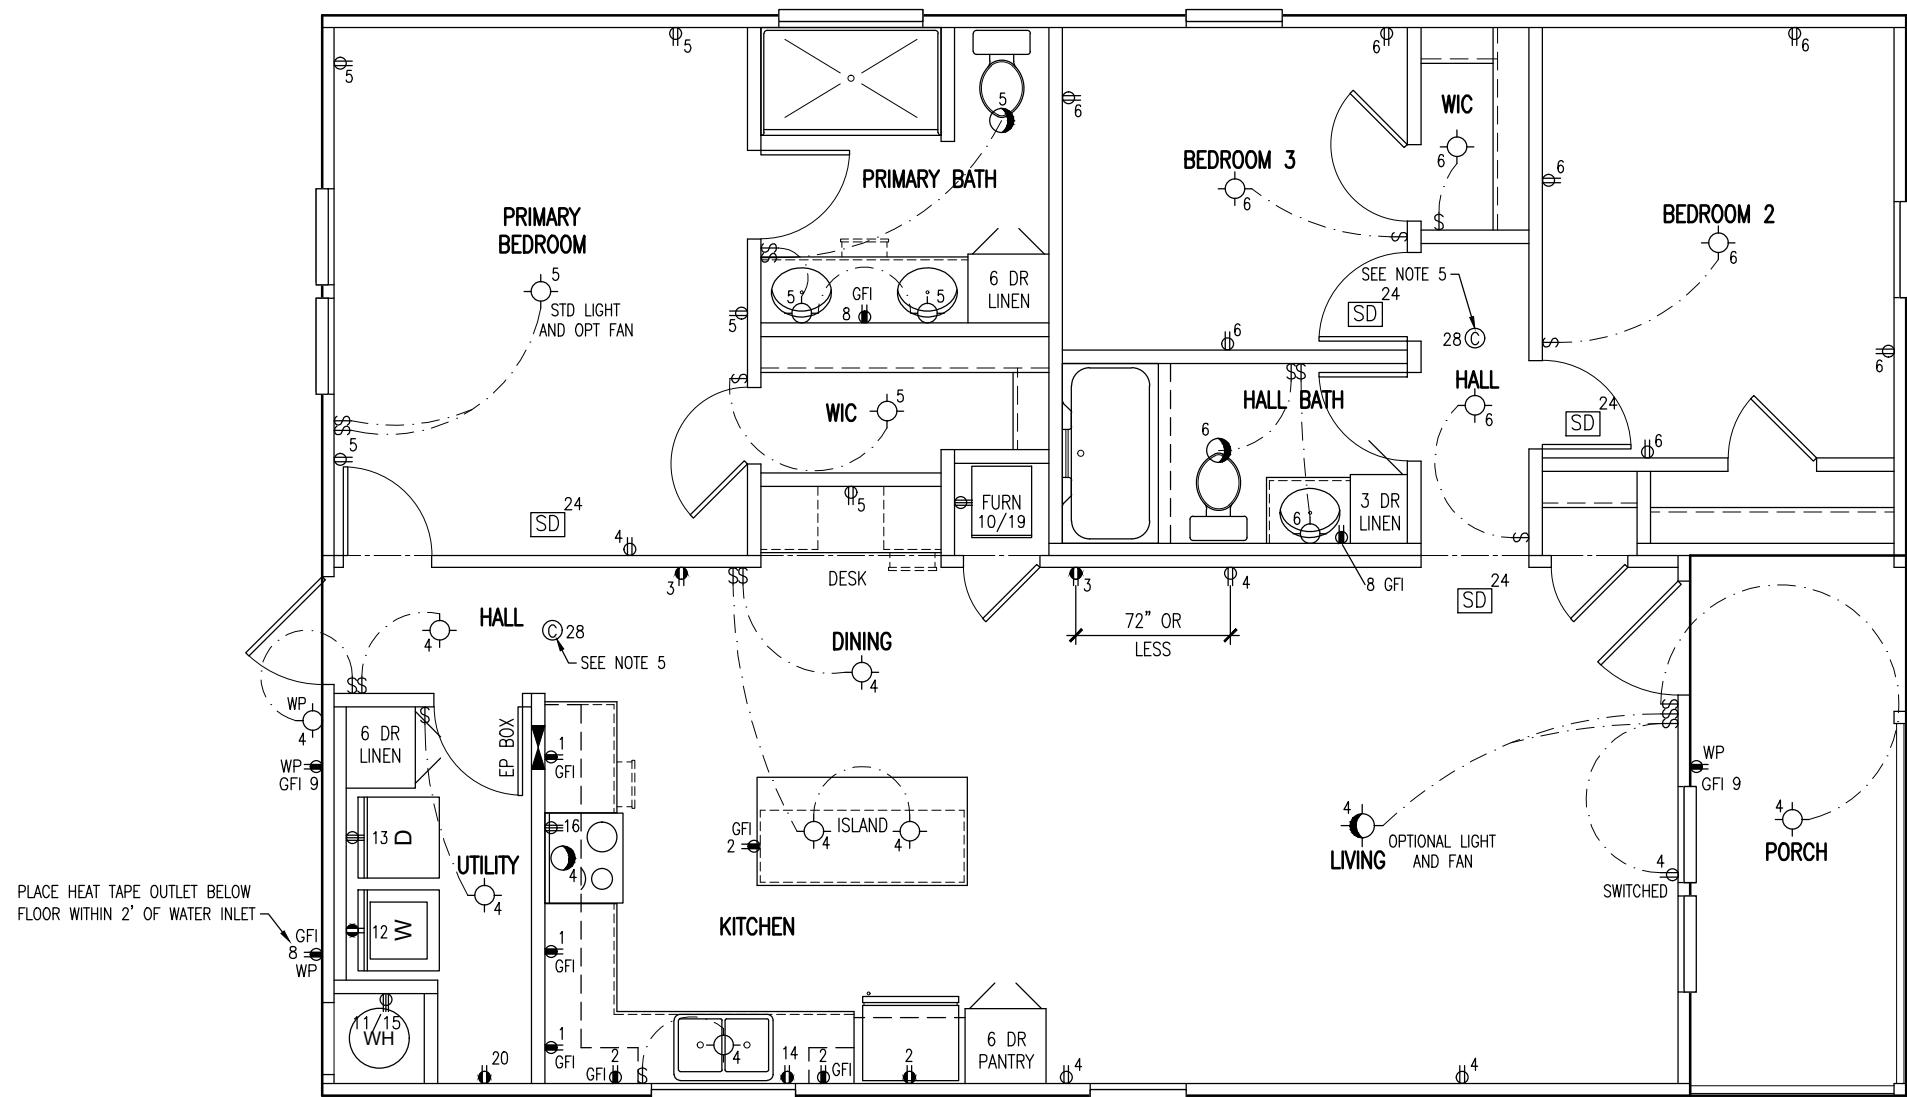

- NOTES:
1. SEE FP-2 FOR ELECTRICAL SCHEDULE AND SYMBOL SCHEDULE.
 2. ELECTRICAL INSTALLATIONS SHALL BE IN ACCORDANCE WITH NFPA-70 NEC 2014.
 3. ISLAND OUTLETS ARE TO BE PLACED WITHIN 6" OF THE SURFACE OF THE COUNTERTOP.
 4. SWITCHED RECEPTACLE OUTLET (BREAK TAB SO ONE OUTLET IS SWITCHED AND OTHER REMAINS POWERED) WHEN A CEILING LIGHT IS USED IN THE LIVING ROOM, SWITCHED OUTLET ISN'T REQUIRED.
 5. CARBON MONOXIDE DETECTOR REQUIRED IF ANY FUEL GAS APPLIANCE IS USED.
 6. CARBON MONOXIDE DETECTOR REQUIRED IF FUEL GAS WATER HEATER OR FURNACE IS INSTALLED.

MODEL:
MARATHON – 32443A

DWG:
FP-32443A.2

DATE:
06/26/2026

SCALE:
3/16" = 1'-0"


TITLE:

ELECTRICAL SUBMITTAL

REF # DESCRIPTION

DATE REVISED BY:



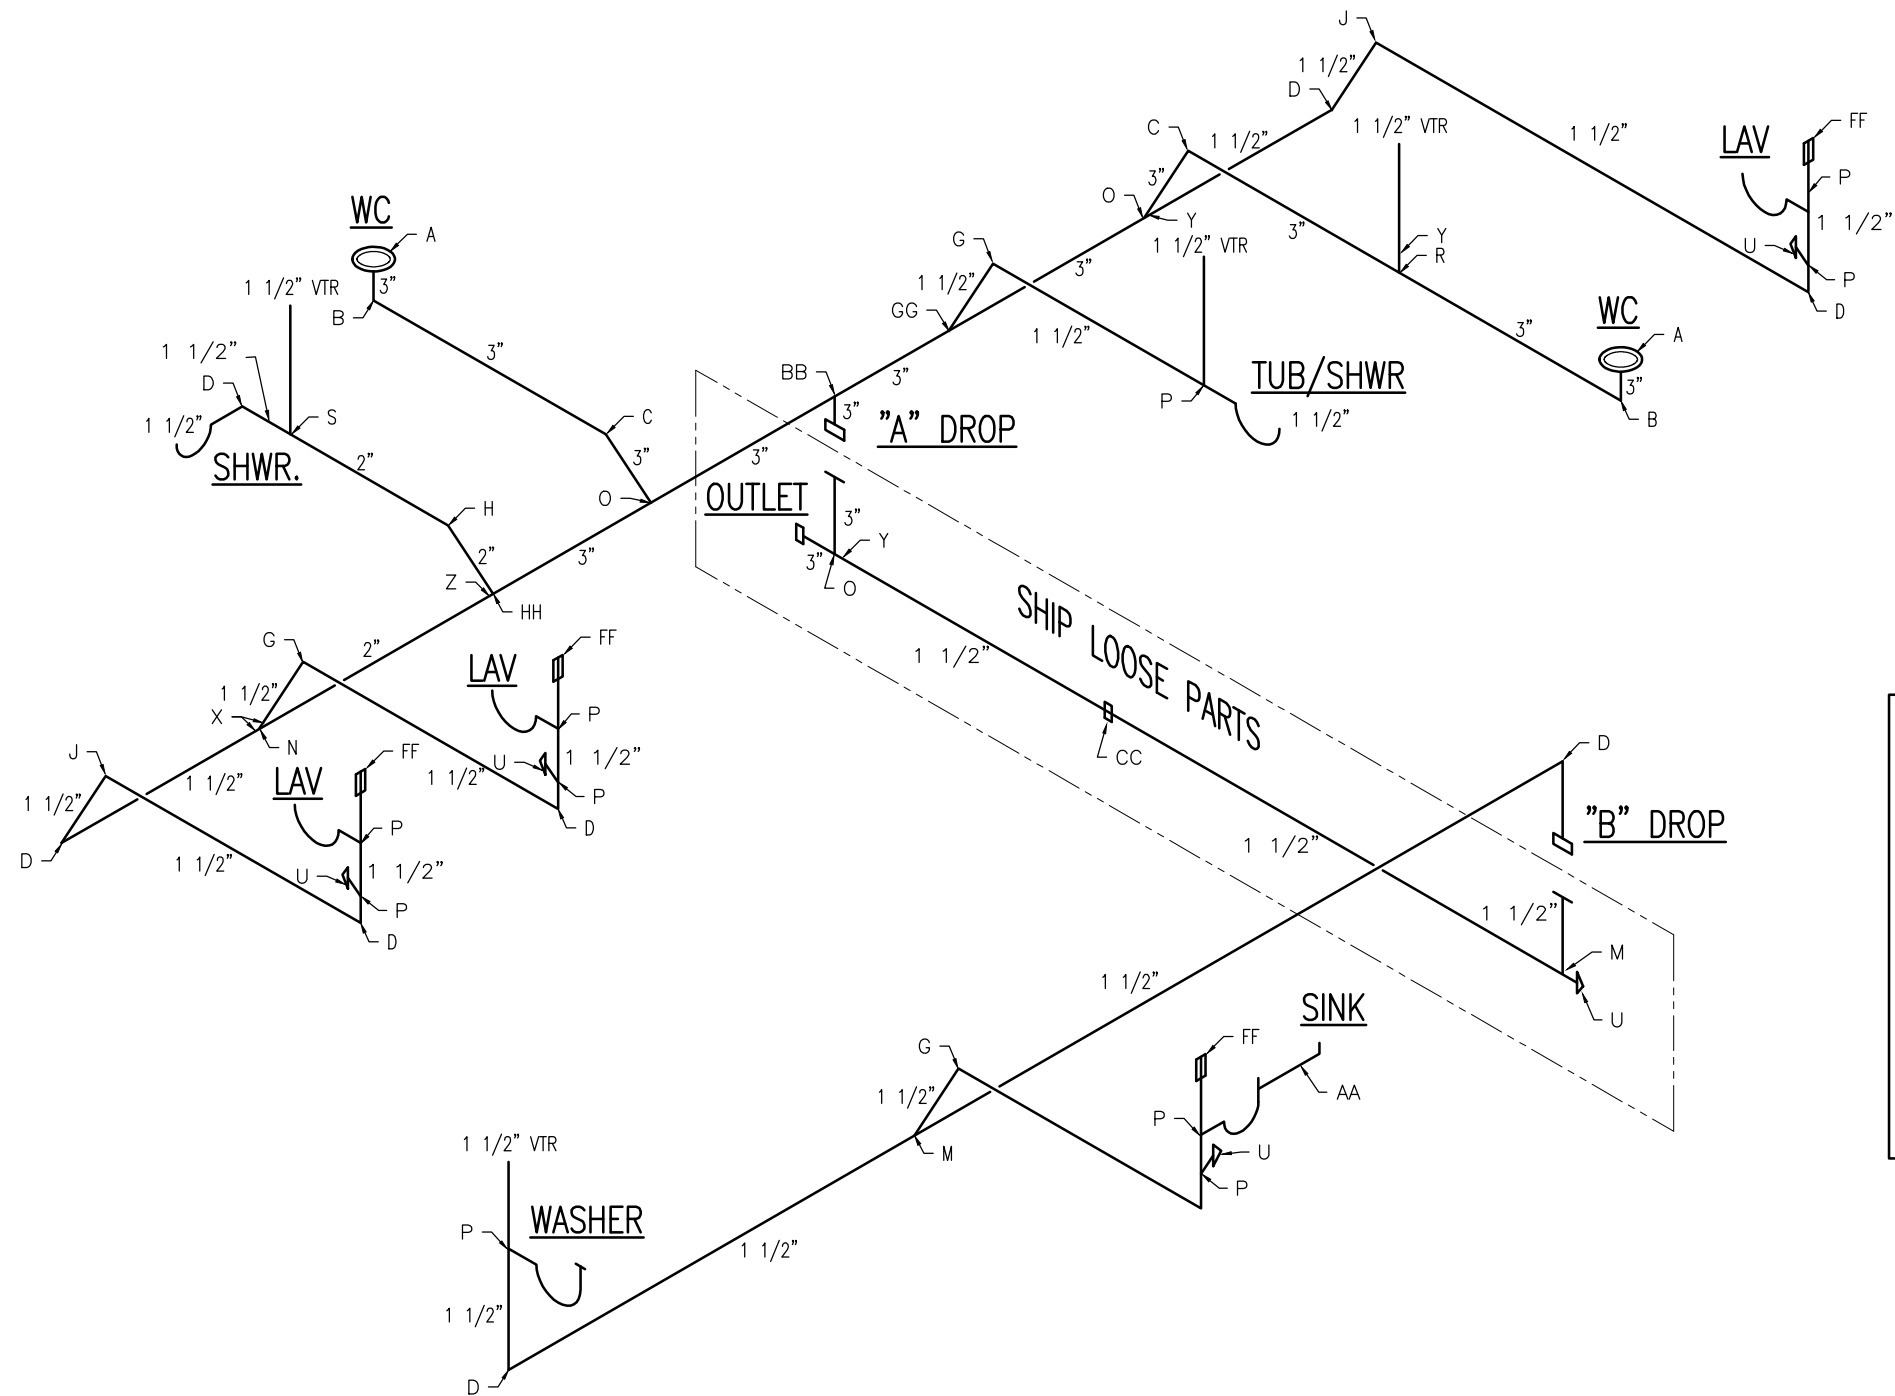

SCHEDULE


	= P-TRAP
	= P-TRAP W/WASHER STAND PIPE
	= CAP AND CHAIN
	= AUTOVENT = FF

NOTES:

1. PIPING SHALL BE SUPPORTED TO PROVIDE 1/4" PER FOOT SLOPE, MINIMUM SLOPE IS 1/8" WITH FULL SIZE CLEAN-OUT AT THE UPPER END.
2. ALL LINES 1 1/2" UNLESS OTHERWISE NOTED.
3. SEE PAGE PL-9 FOR FITTING SCHEDULE.


MODEL: MARATHON — 32443A	DATE: 07/06/2026	TITLE: DRAIN—WASTE—VENT			
DWG: FP-32443A.3	SCALE: NO SCALE	REF #	DESCRIPTION	DATE	REVISED BY:
		-	-	-	-



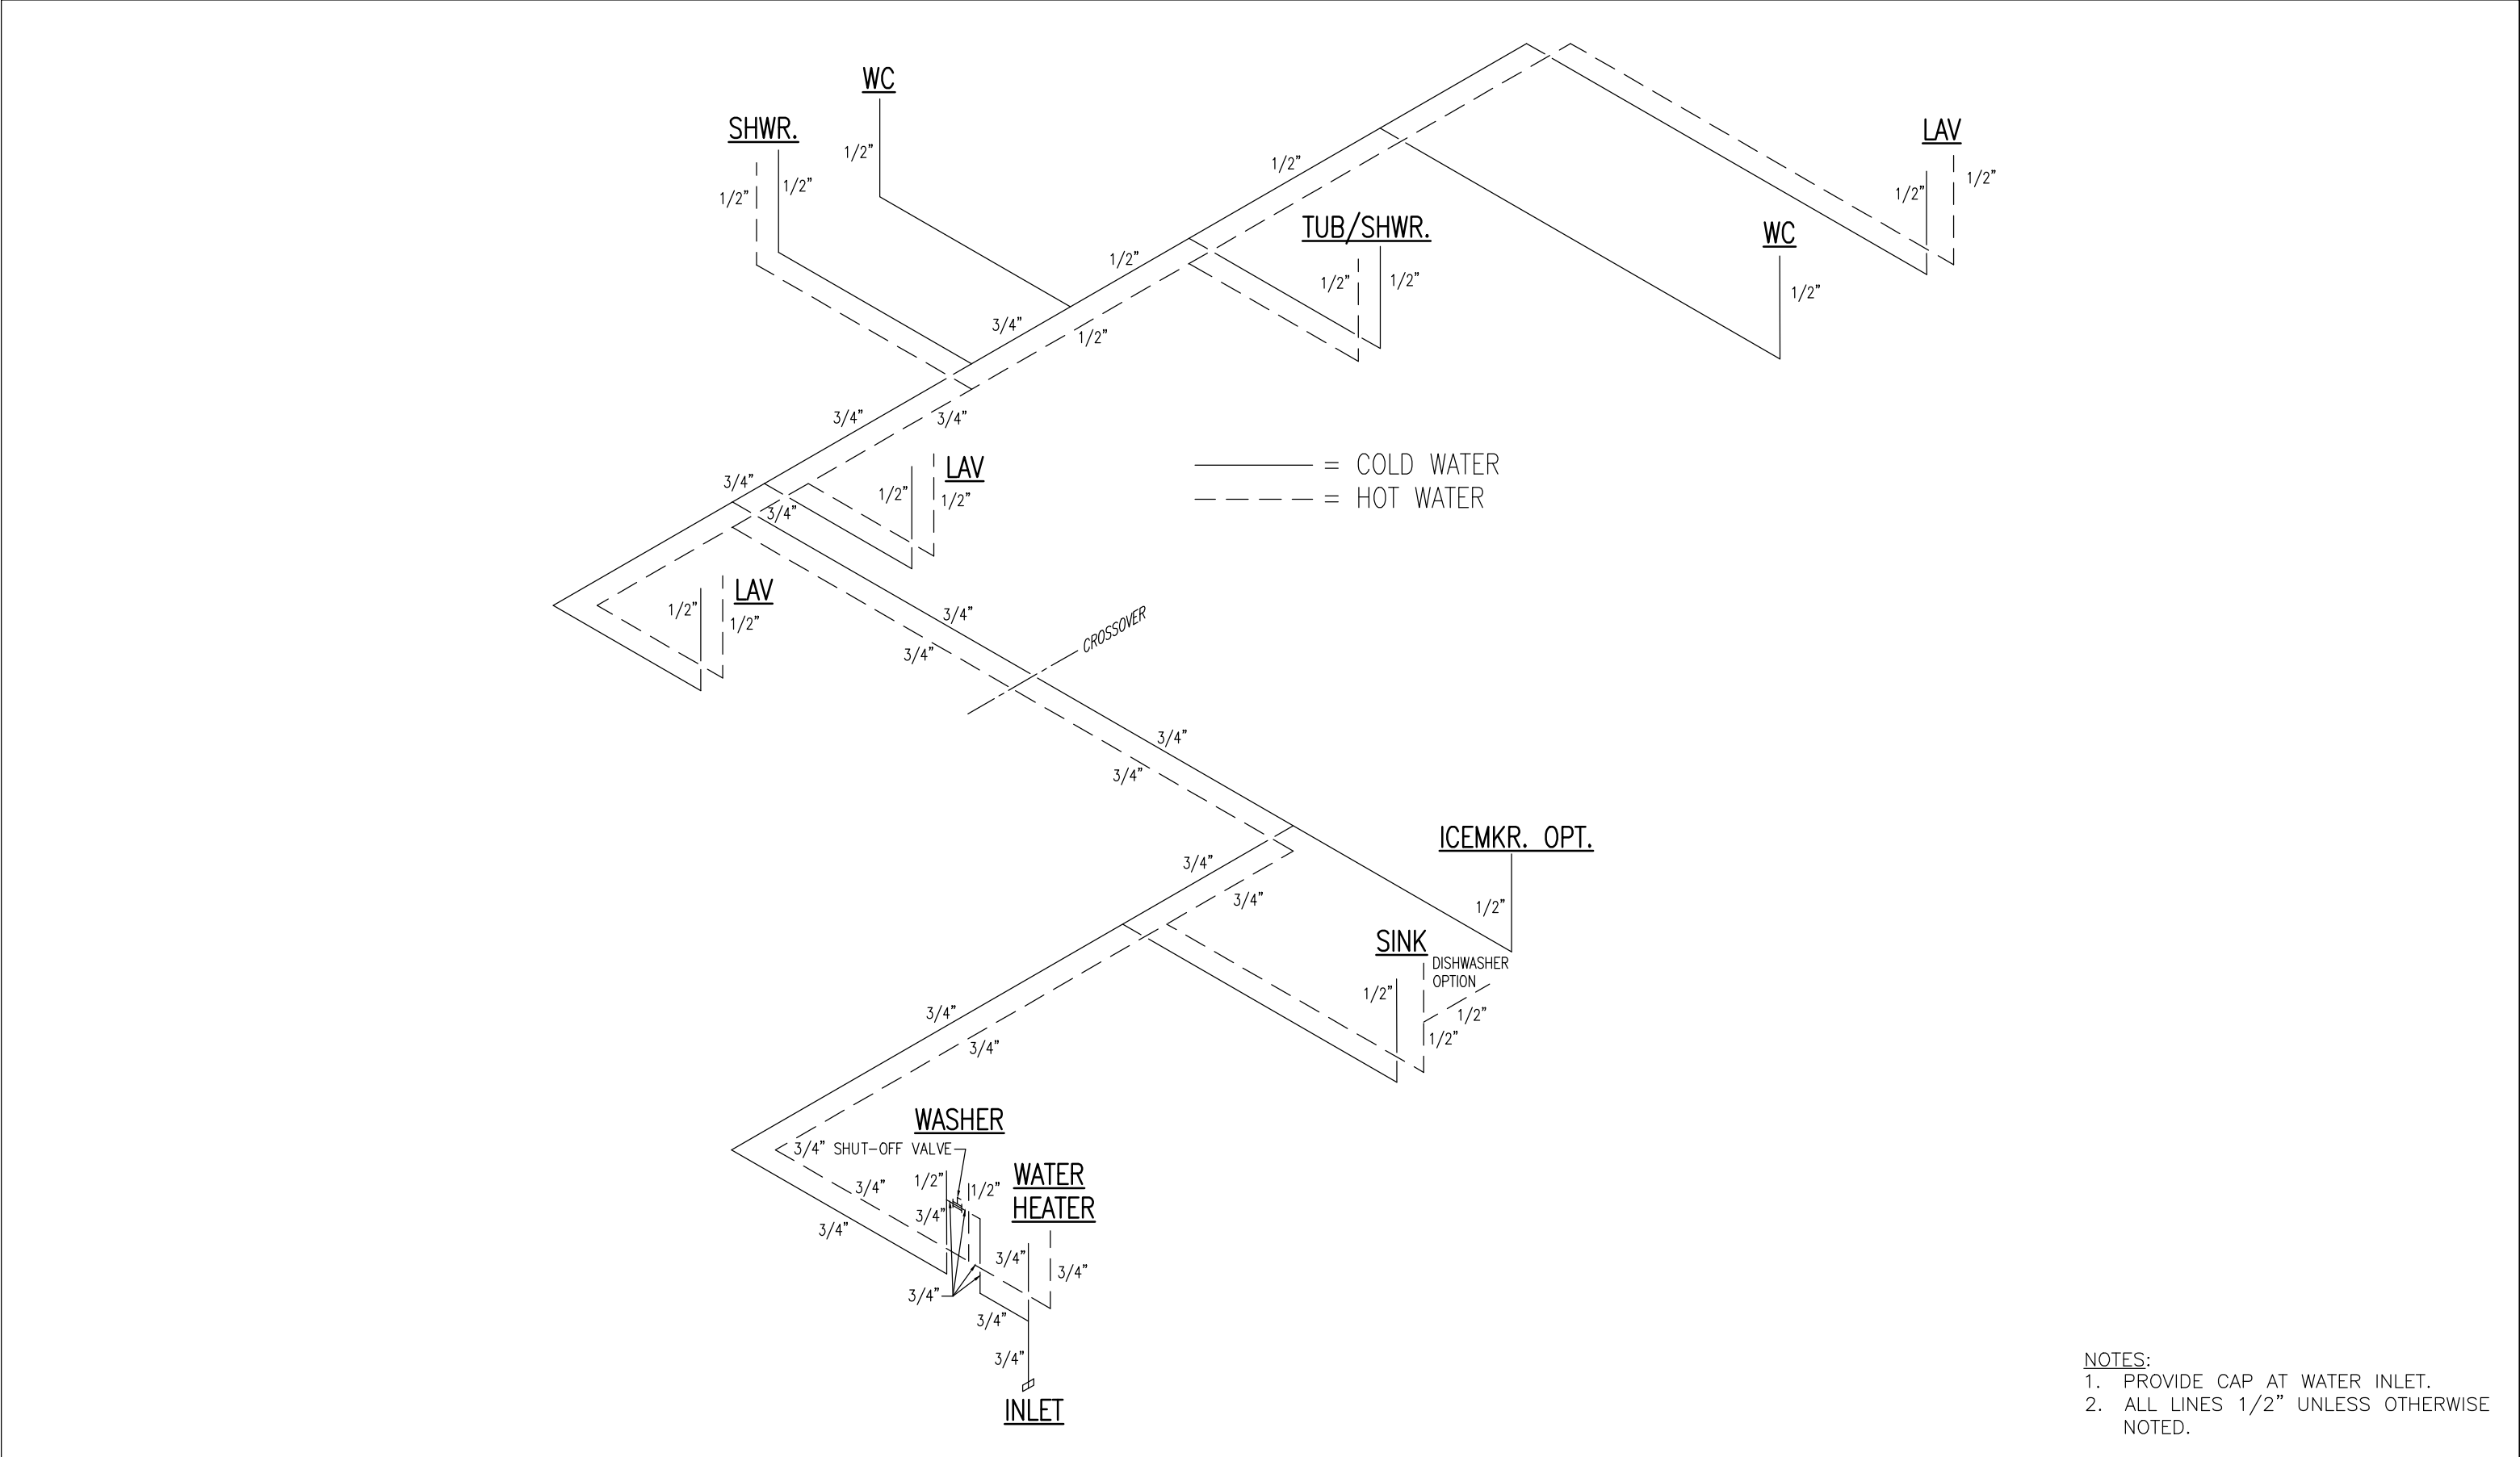

MODEL:	DATE:	TITLE:			
MARATHON – 32443A	07/06/2026	WATER SUPPLY SUBMITTAL			
DWG:	SCALE:	REF #	DESCRIPTION	DATE	REVISED BY:
FP–32443A.4	NO SCALE	–	–	–	–




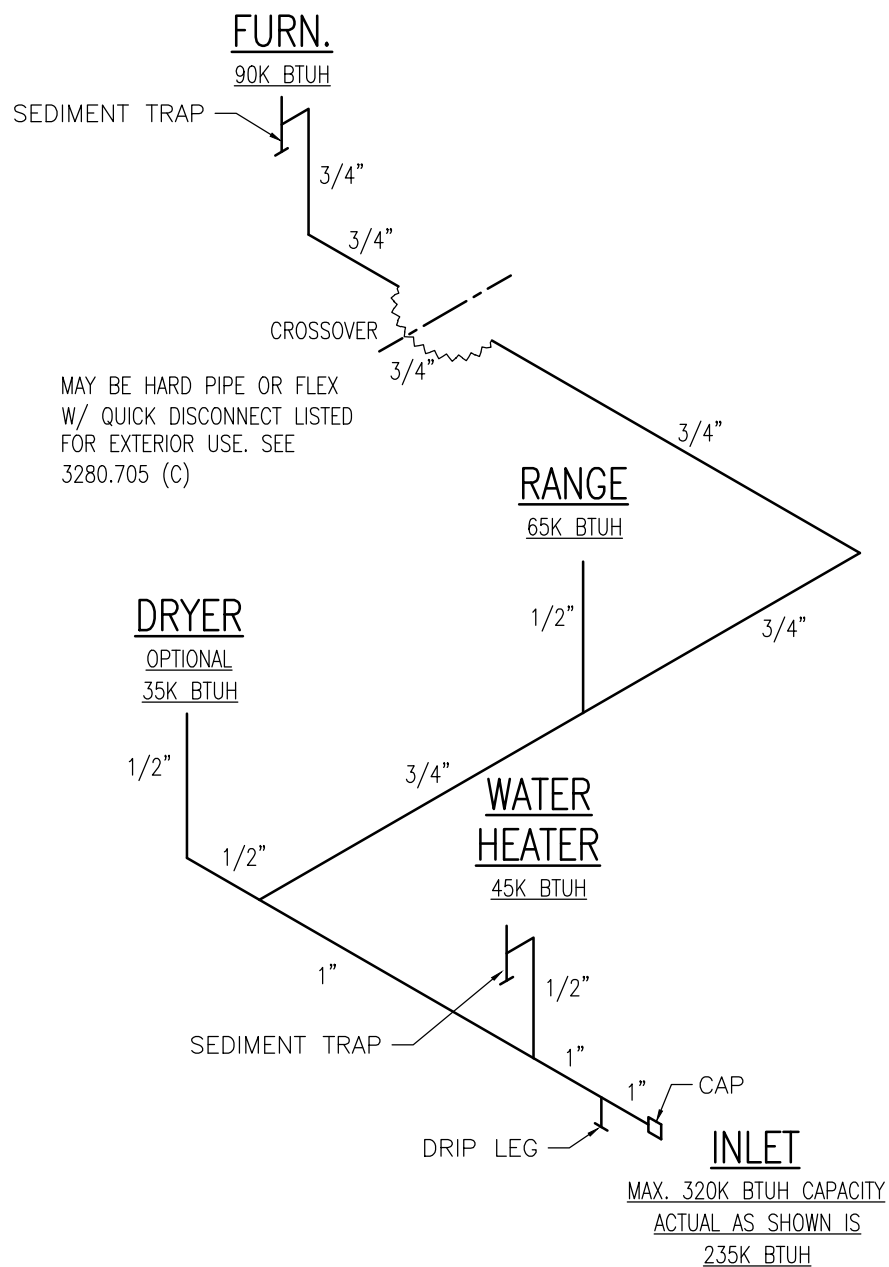

- NOTES:
1. SHUT-OFF VALVE AND FLEX CONNECTOR SHALL BE PROVIDED AT EACH FIXTURE.
 2. MAXIMUM DEVELOPED LENGTH IS 40’.
 3. APPLIANCE BTUH IS ASSUMED TO BE MAXIMUM AND ACTUAL APPLIANCE SHALL NOT EXCEED THE VALUE SHOWN.

MODEL:	MARATHON – 32443A	DATE:	07/06/2026	TITLE:				FUEL GAS SUPPLY SUBMITTAL			
DWG:	FP-32443A.5	SCALE:	NO SCALE	REF #	DESCRIPTION				DATE	REVISED BY:	
				-	-				-	-	



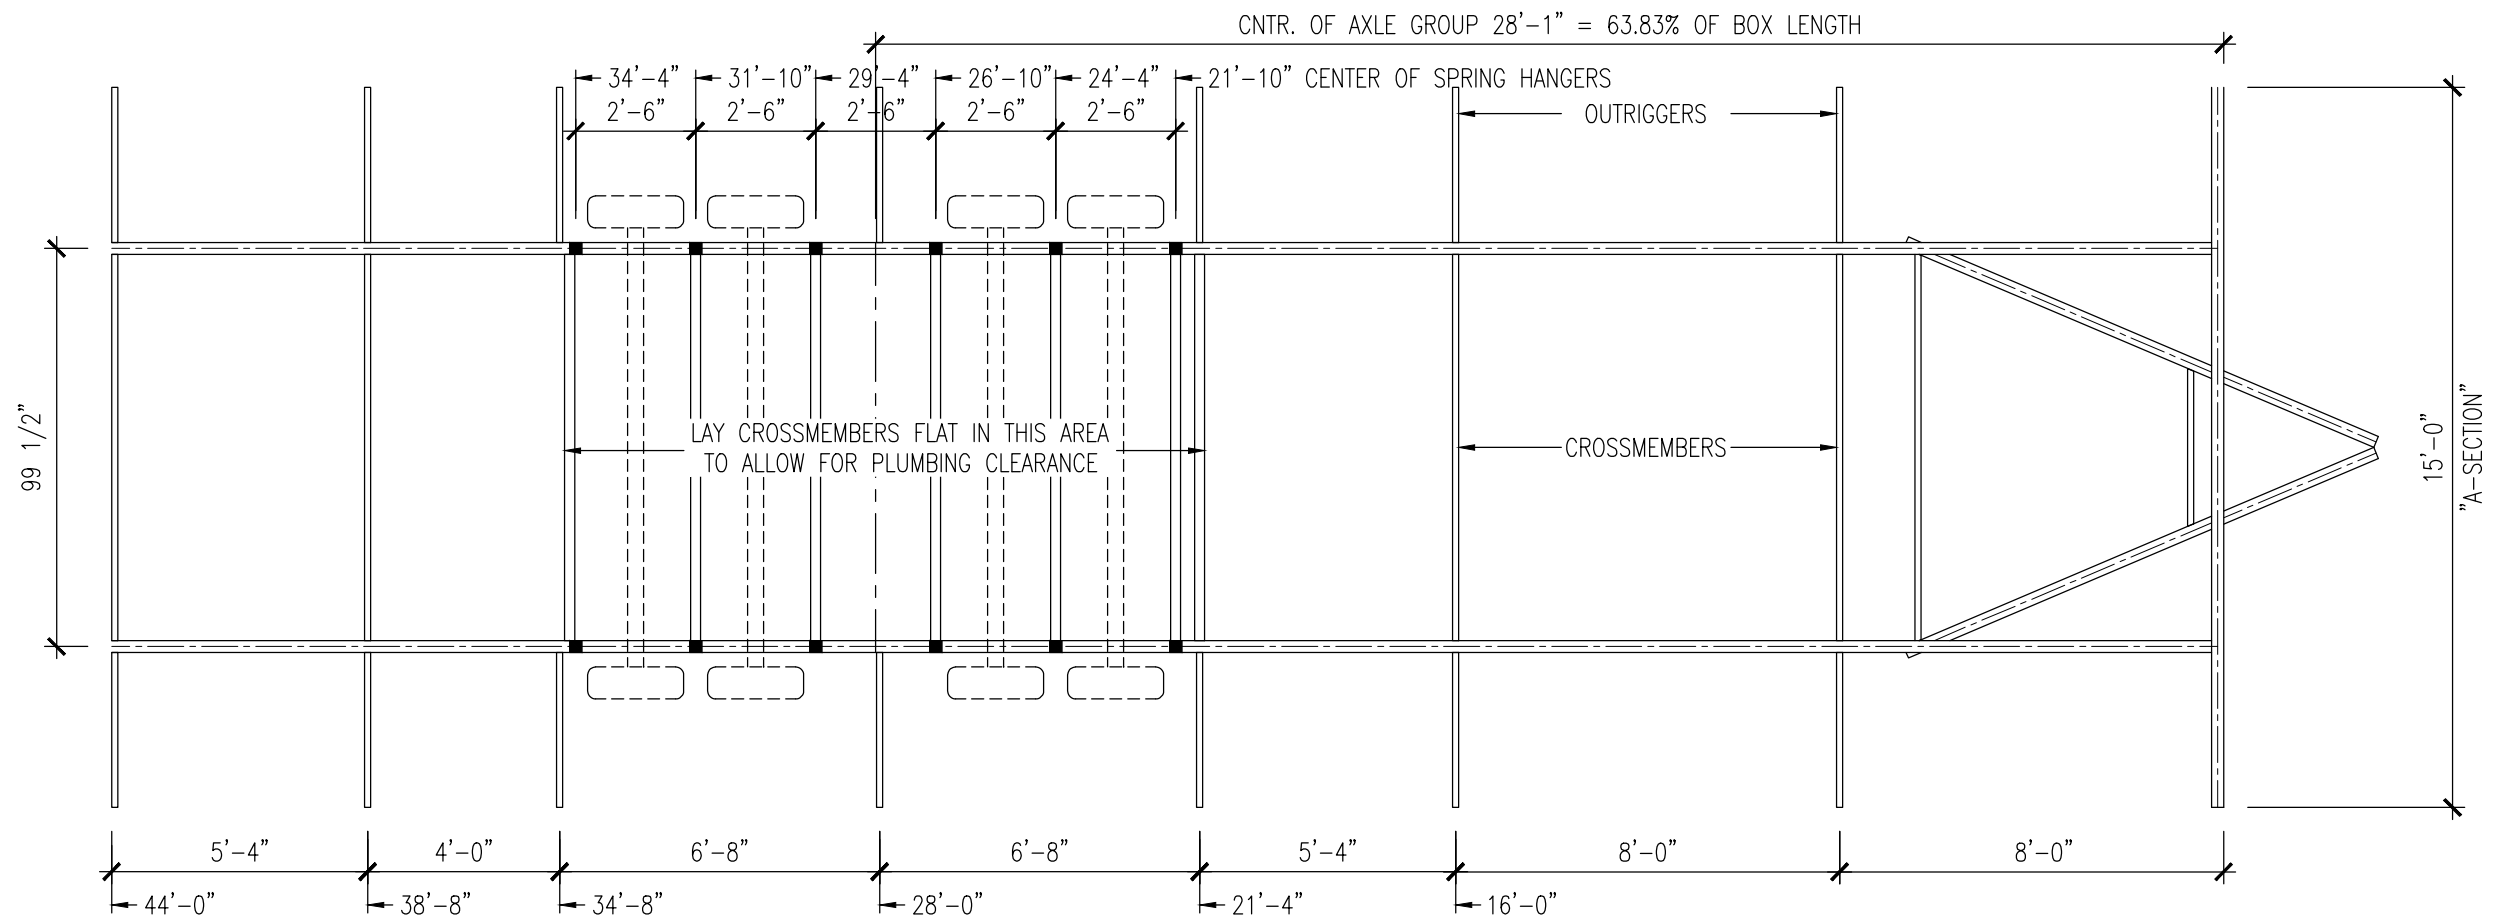

MODEL:
MARATHON – 32443A

DWG:
FP-32443A.CH

DATE:
06/26/2026


SCALE:
1/4" = 1'-0"

TITLE:
CHASSIS "A" SECTION

REF #	DESCRIPTION
-	-

DATE	REVISED BY:
-	-



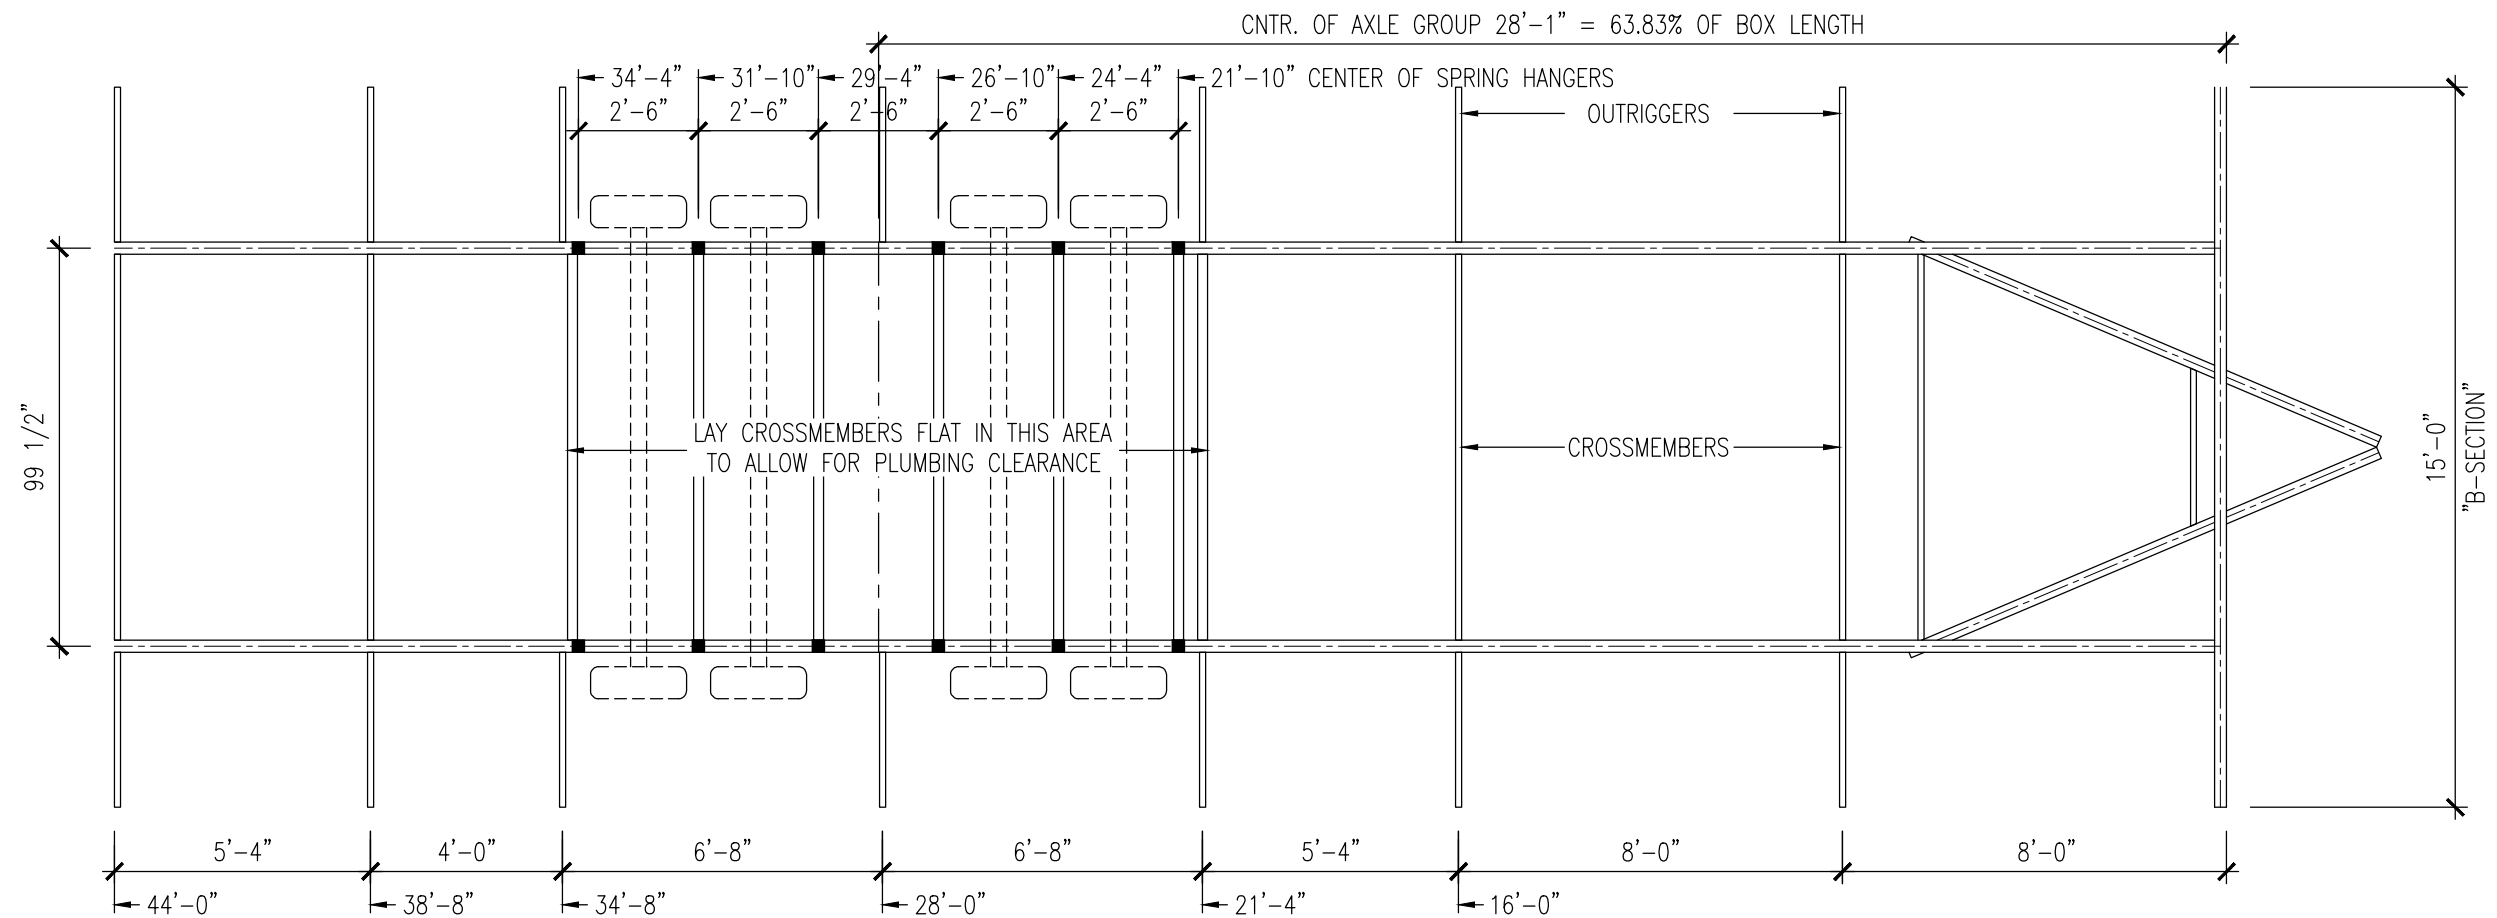

MODEL:
MARATHON – 32443A

DATE:
06/26/2026

TITLE:

CHASSIS "B" SECTION



DWG:
FP-32443A.CH

SCALE:
1/4" = 1'-0"

REF #	DESCRIPTION
-	-

DATE	REVISED BY:
-	-



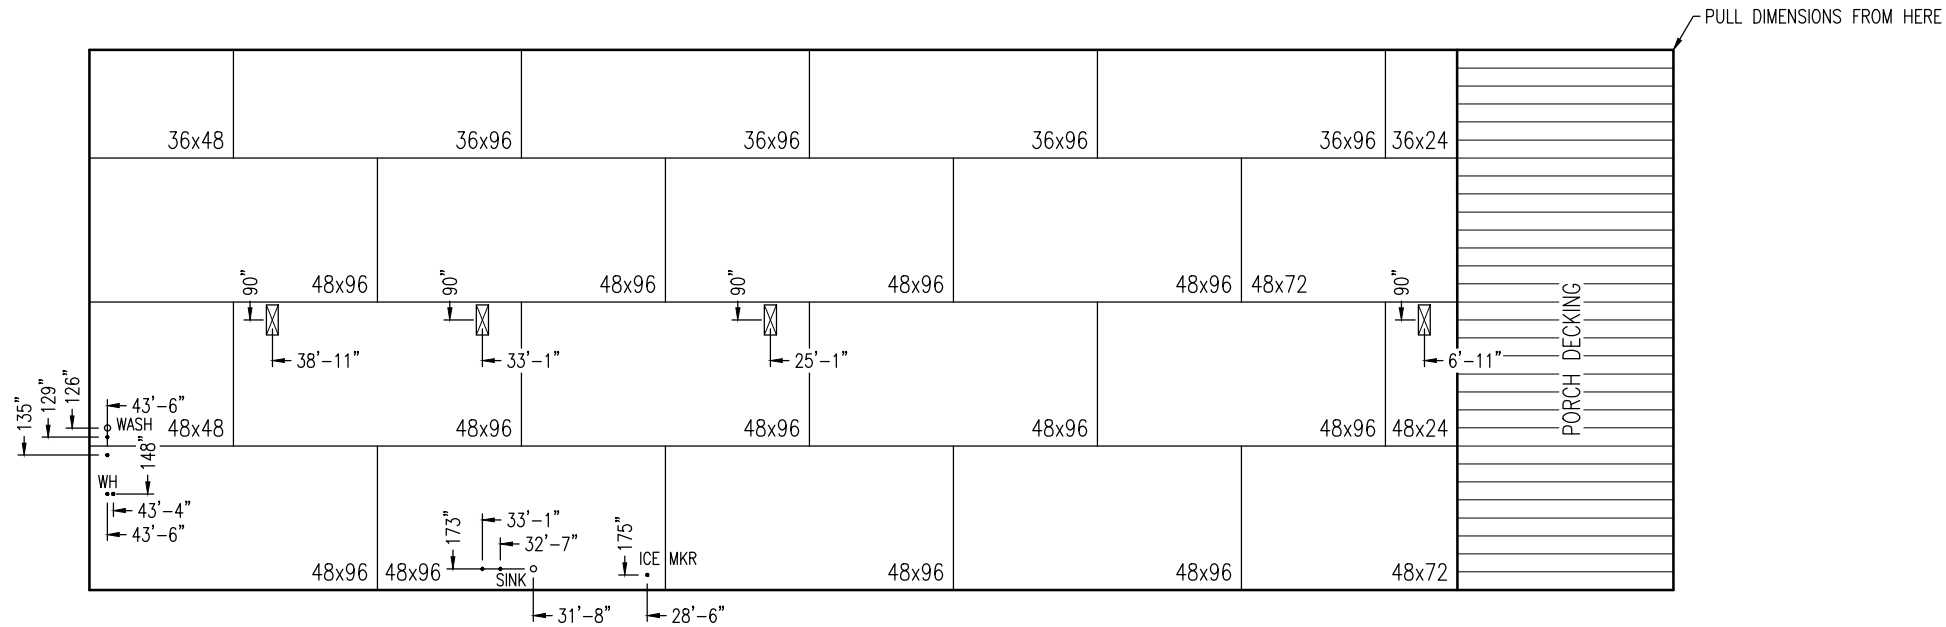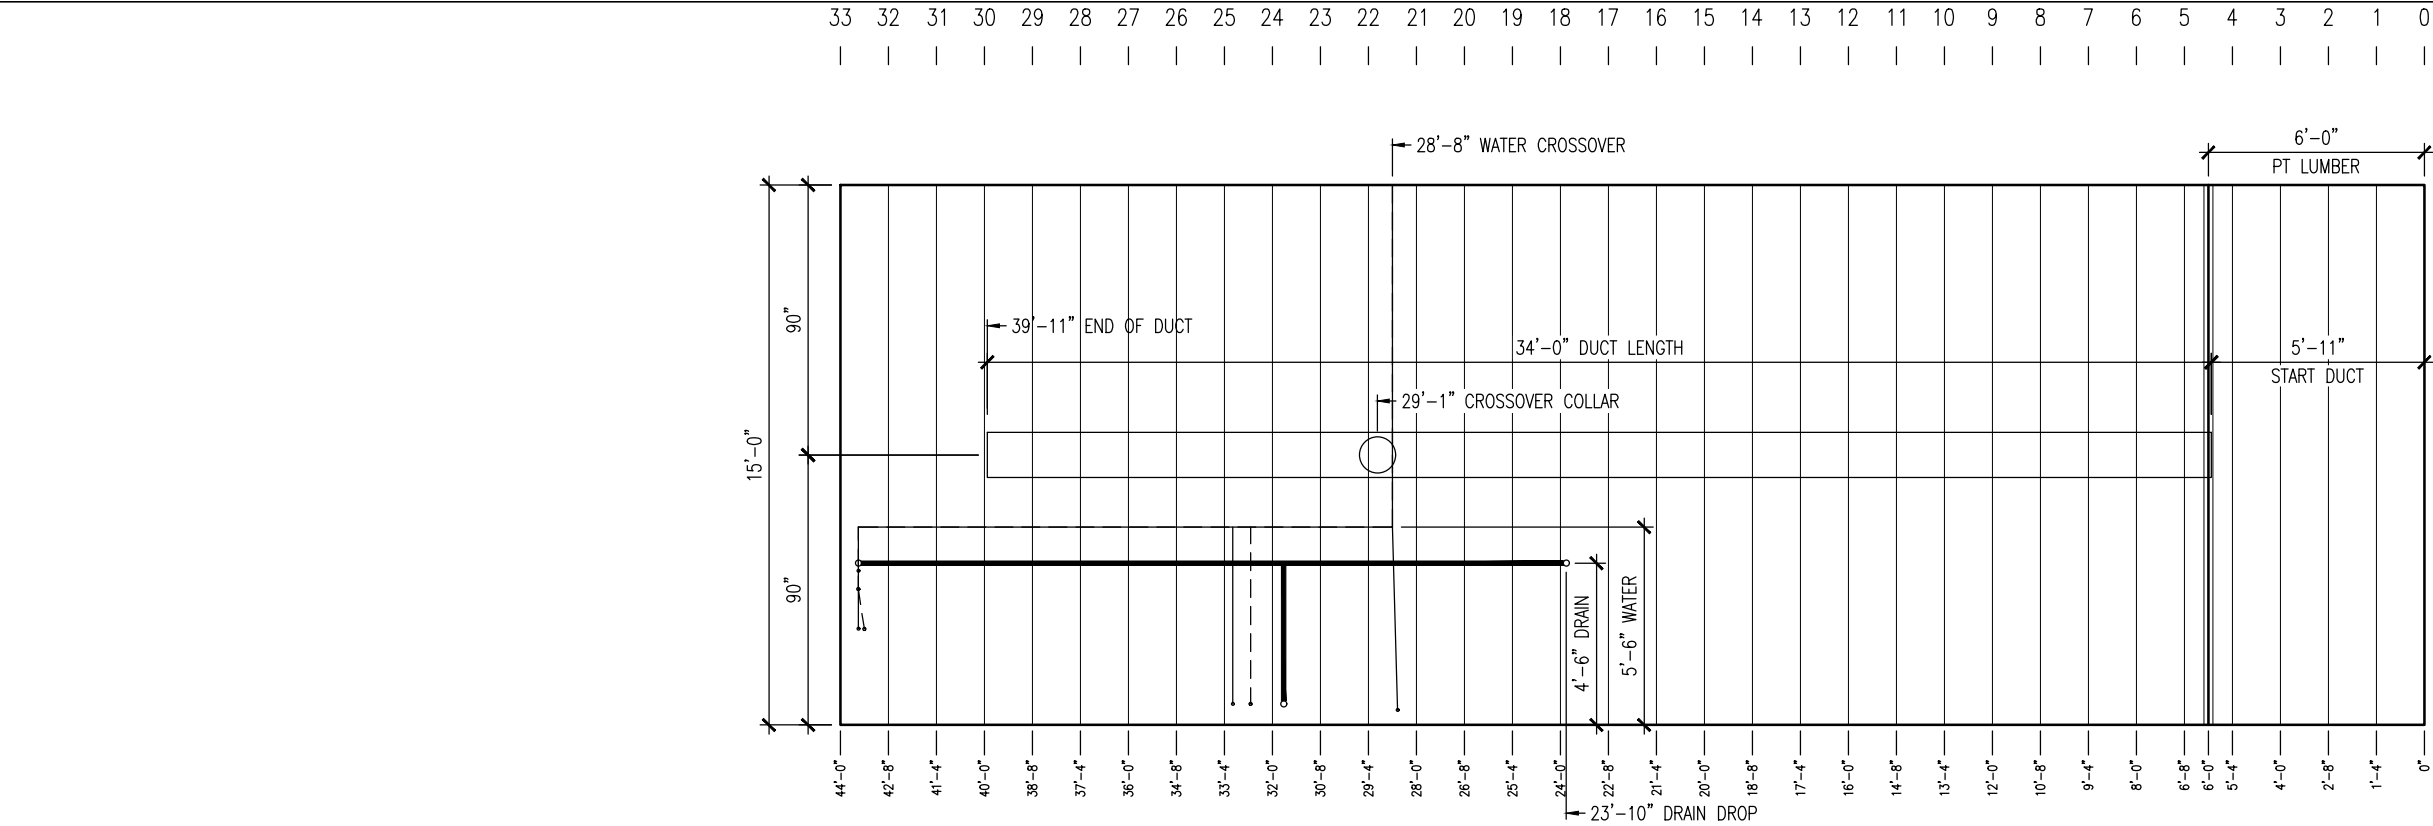


- WC FLANGE
- DRAIN/VENT
- WATER
- TUB P-TRAP
- HVAC REGISTER


MODEL:	DATE:	TITLE:				
MARATHON – 32443A	06/26/2026	"B" FLOOR FRAMING & DECKING				
DWG:	SCALE:	REF #	DESCRIPTION	DATE	REVISED BY:	
FP-32443A	3/16" = 1'-0"	-	-	-	-	




COLD WATER SYSTEM

 DIMENSIONS DO NOT INCLUDE RISERS.

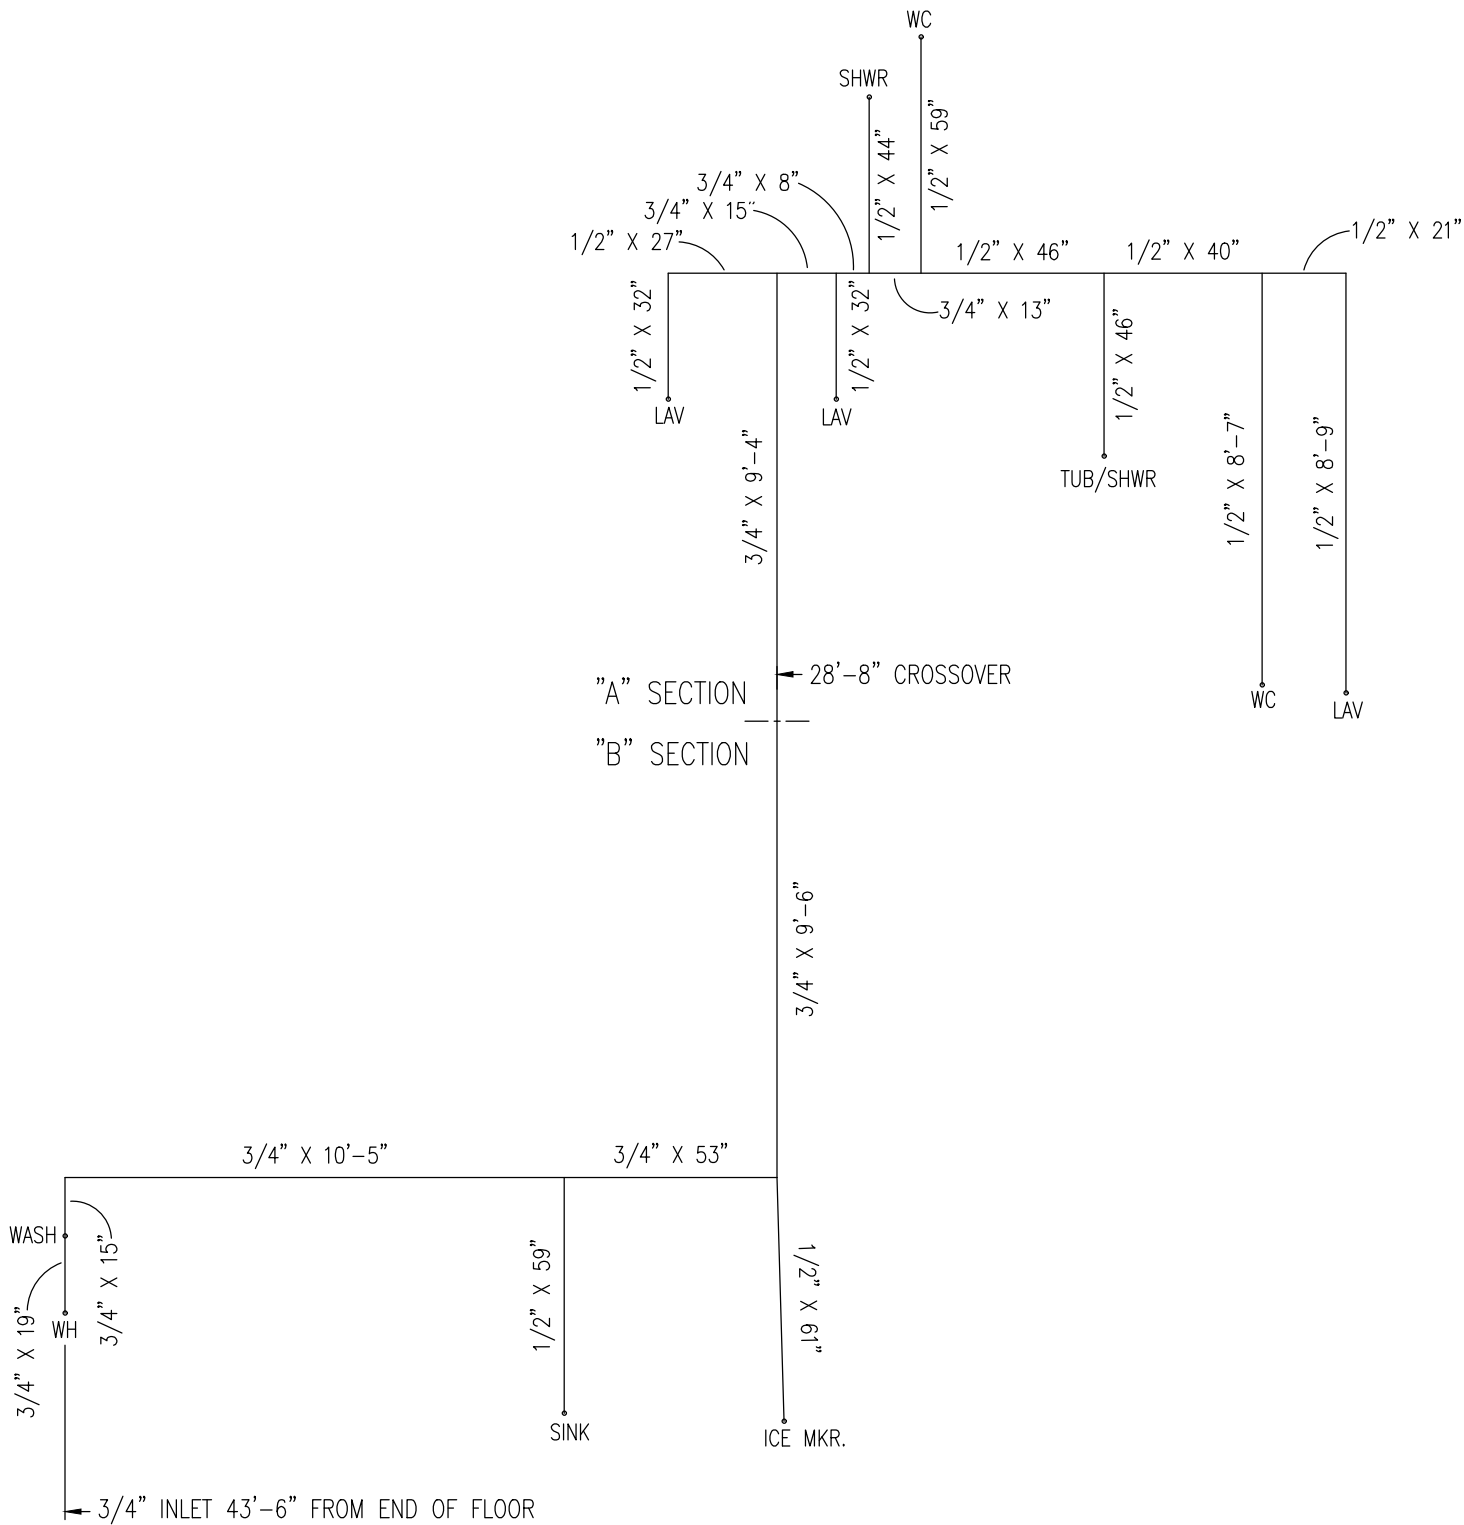

MODEL:	DATE:	TITLE:					
MARATHON – 32443A	07/23/2026	WATER SUPPLY – COLD					
DWG:	SCALE:	REF #	DESCRIPTION	DATE	REVISED BY:		
FP–32443A	1/4" = 1'–0"	–	–	–	–		

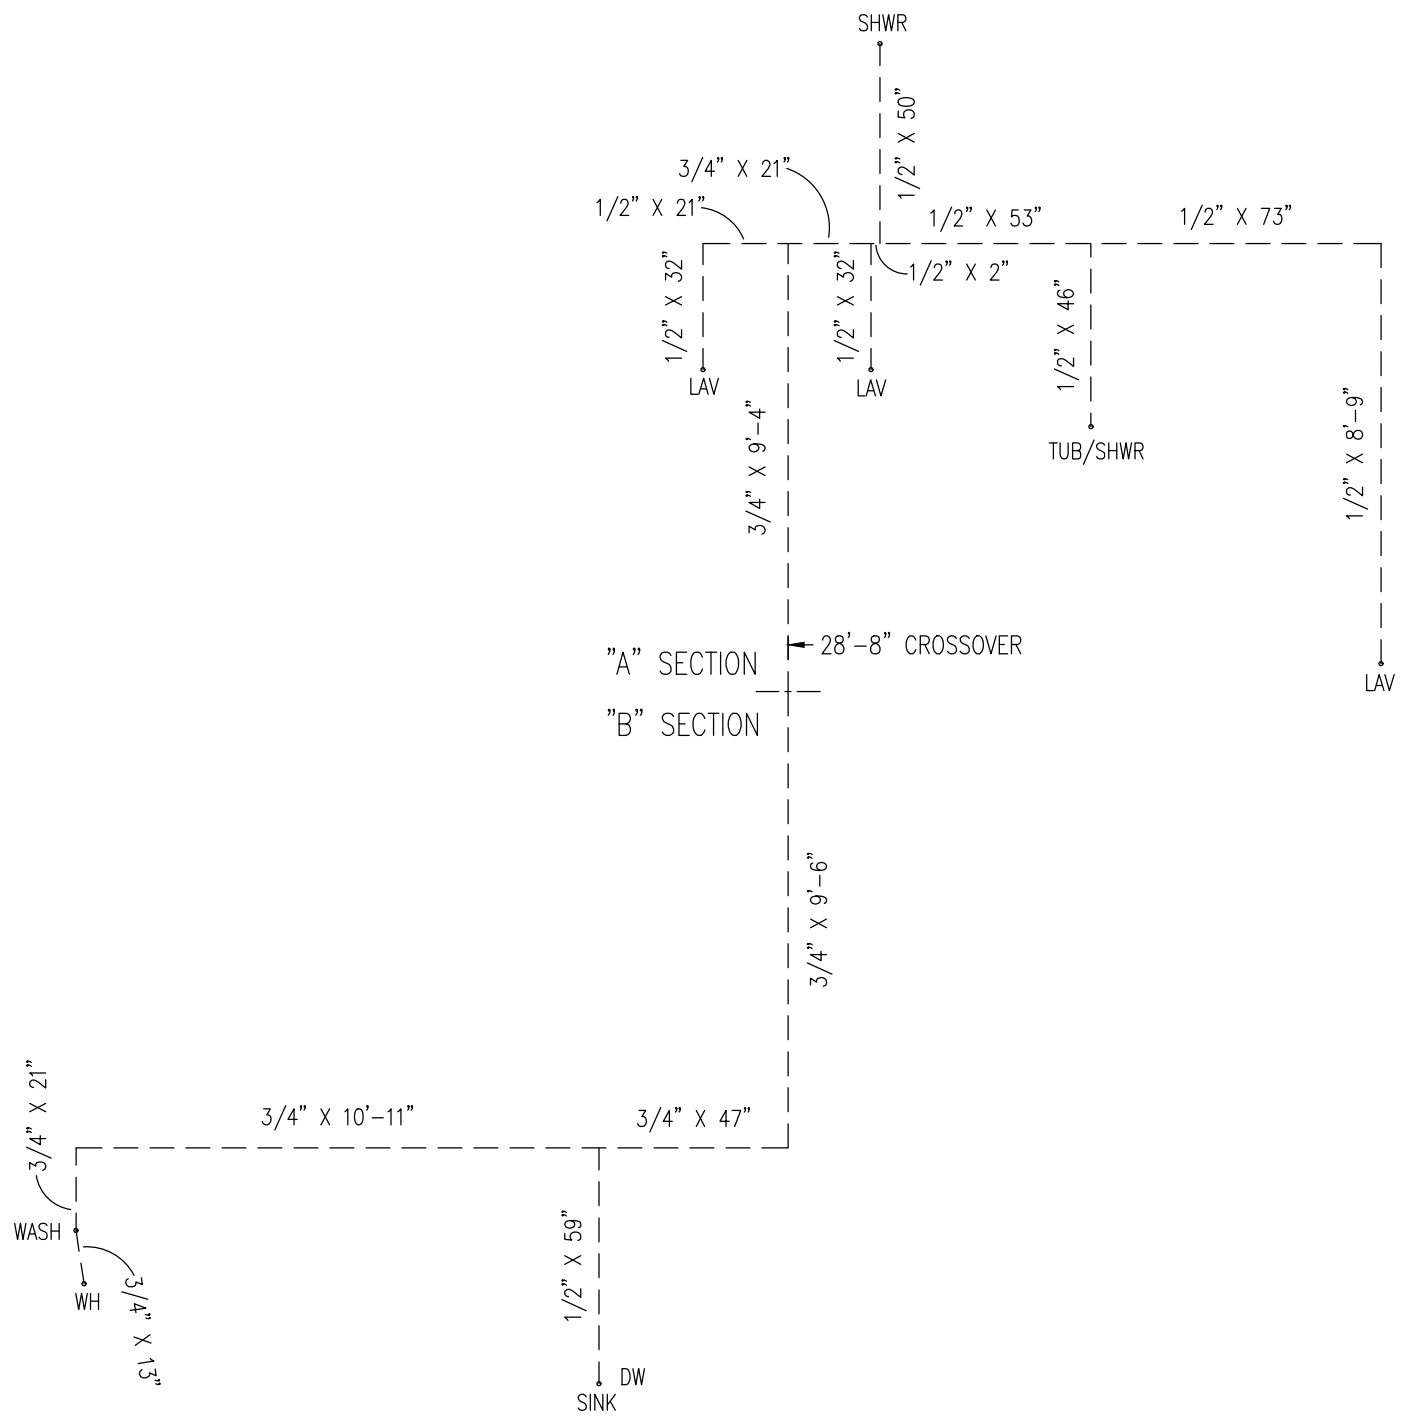


HOT WATER SYSTEM

DIMENSIONS DO NOT INCLUDE RISERS.

MODEL: MARATHON — 32443A	DATE: 07/23/2026	TITLE: WATER SUPPLY — HOT			
DWG: FP—32443A	SCALE: 1/4" = 1'-0"	REF #	DESCRIPTION	DATE	REVISED BY:
		-	-	-	-



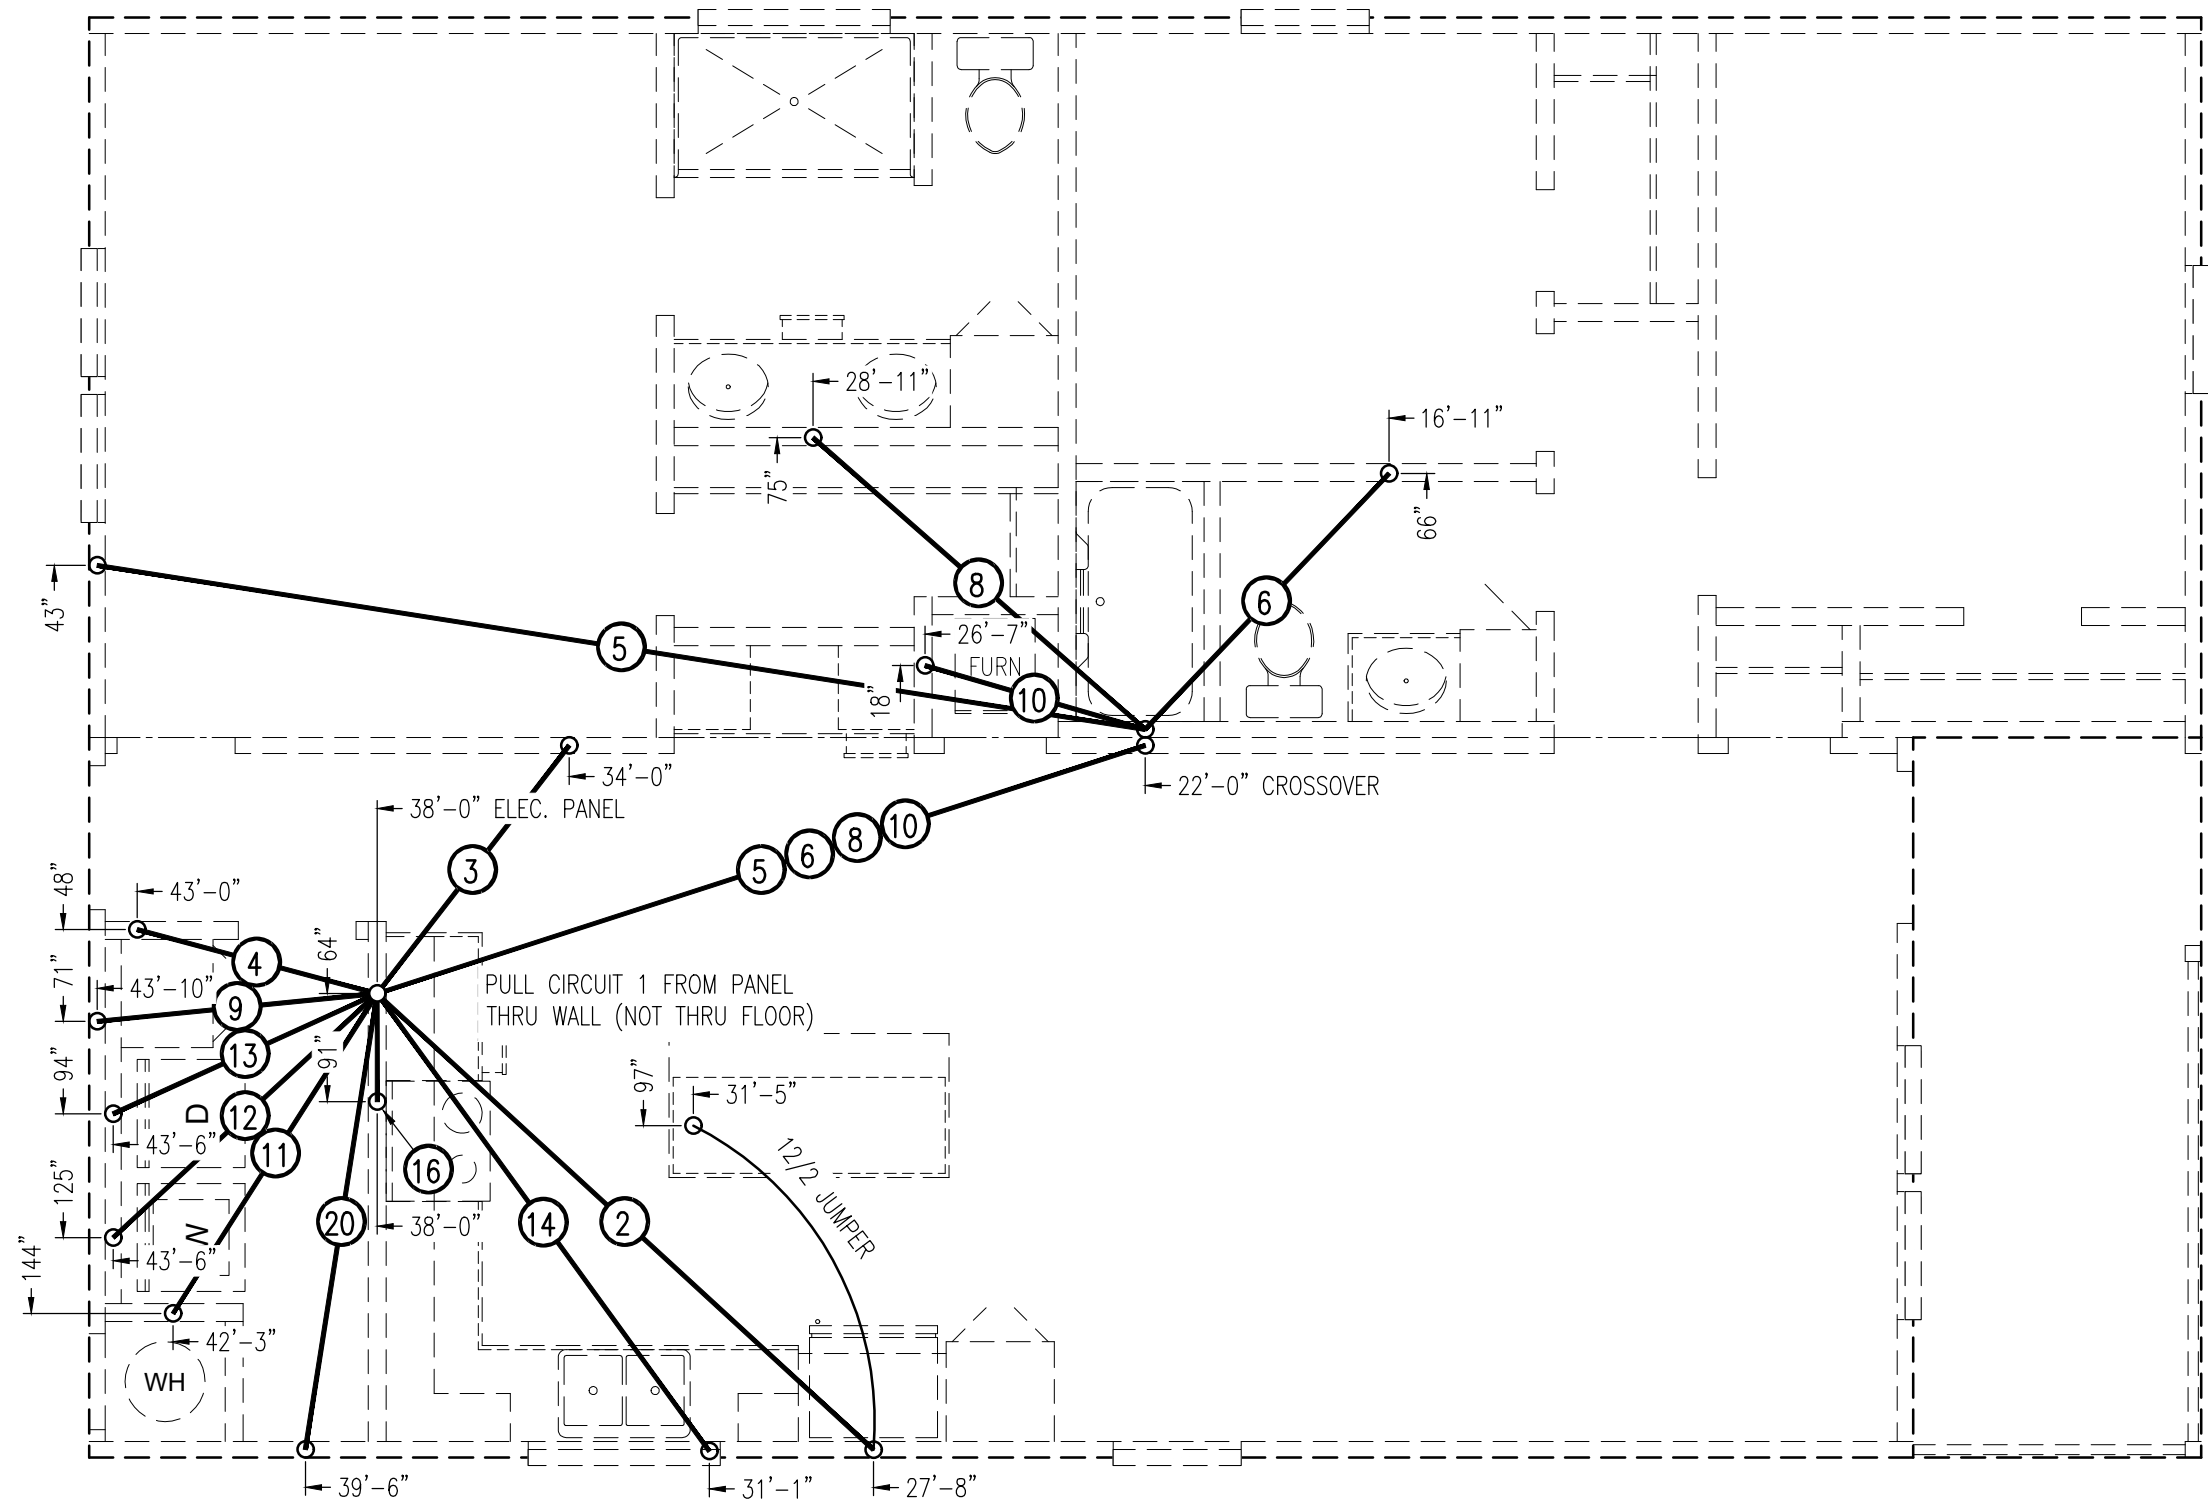

MODEL:
MARATHON — 32443A

DWG:
FP-32443A

DATE:
07/23/2026

SCALE:
1/4" = 1'-0"


TITLE:

FLOOR WIRE

REF #	DESCRIPTION
-	-

DATE	REVISED BY:
-	-



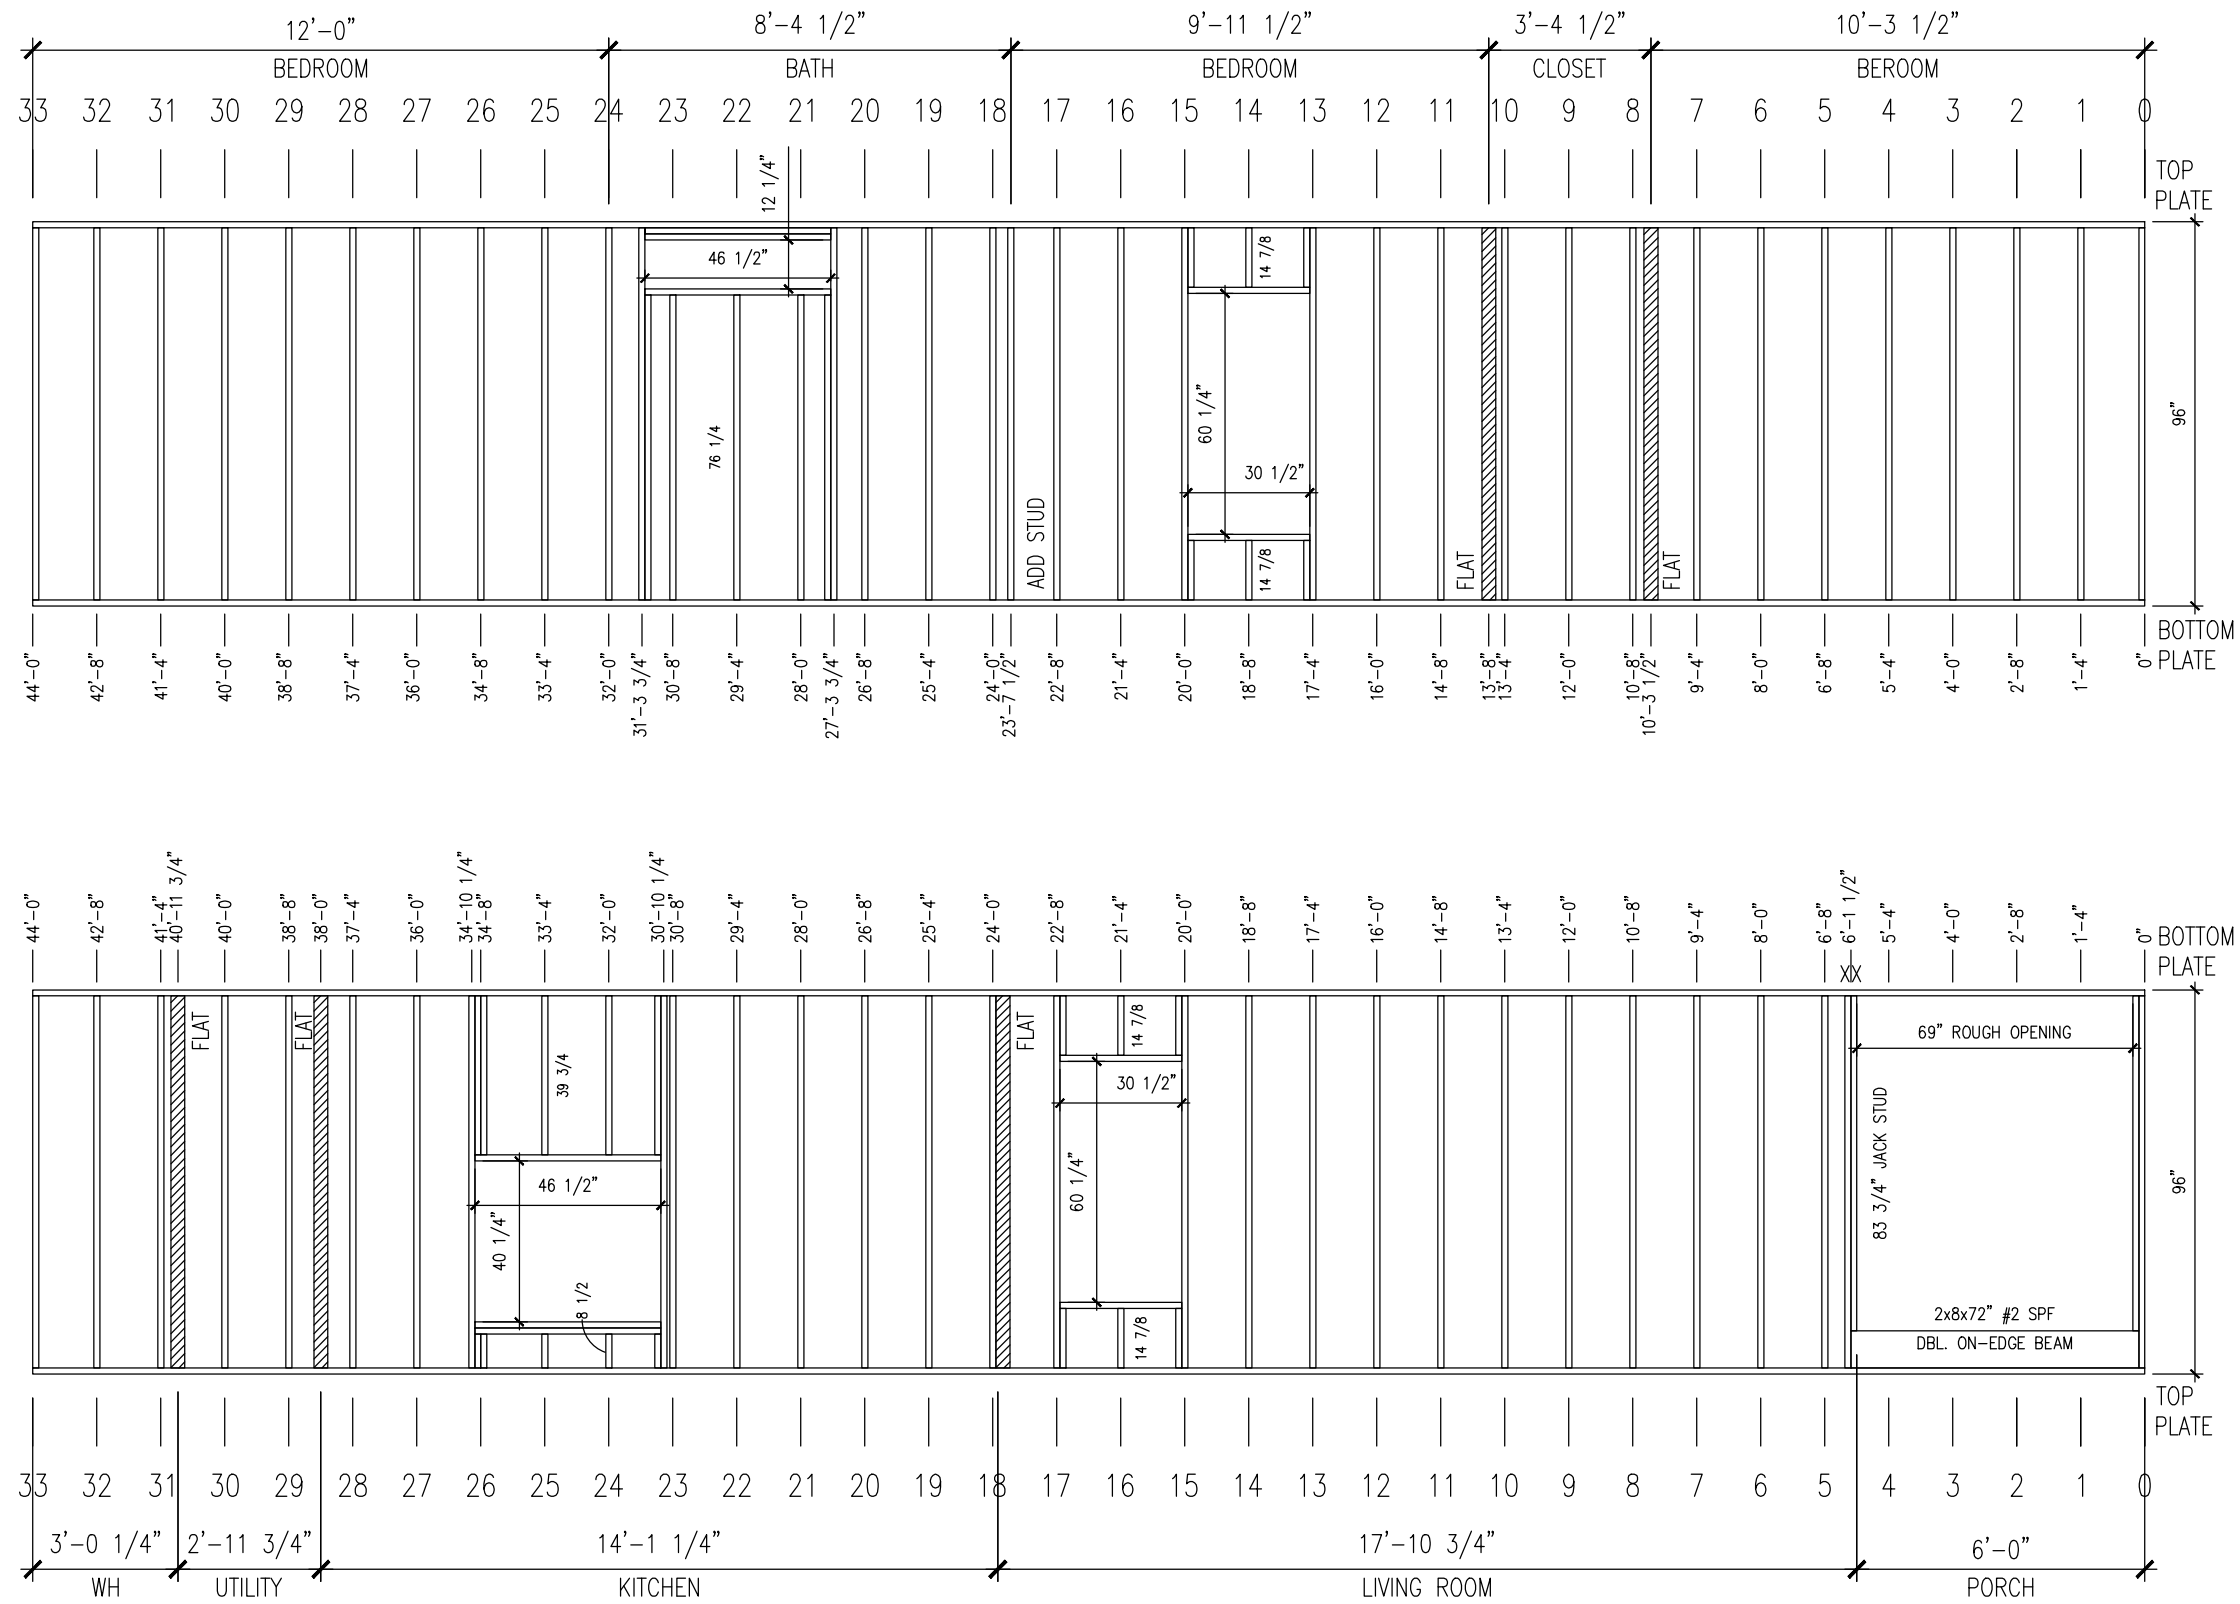





MODEL: MARATHON — 32443A
DWG: FP—32443A

DATE: 07/23/2026
SCALE: 1/4" = 1'-0"

TITLE: SIDEWALLS	
REF #	DESCRIPTION
-	-

DATE	REVISED BY:
-	-



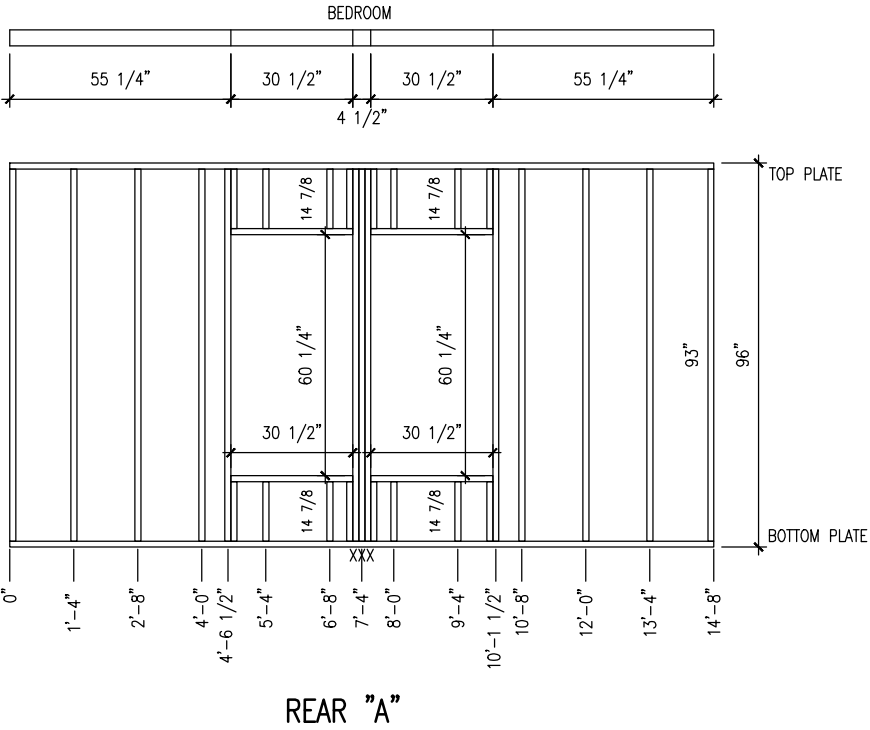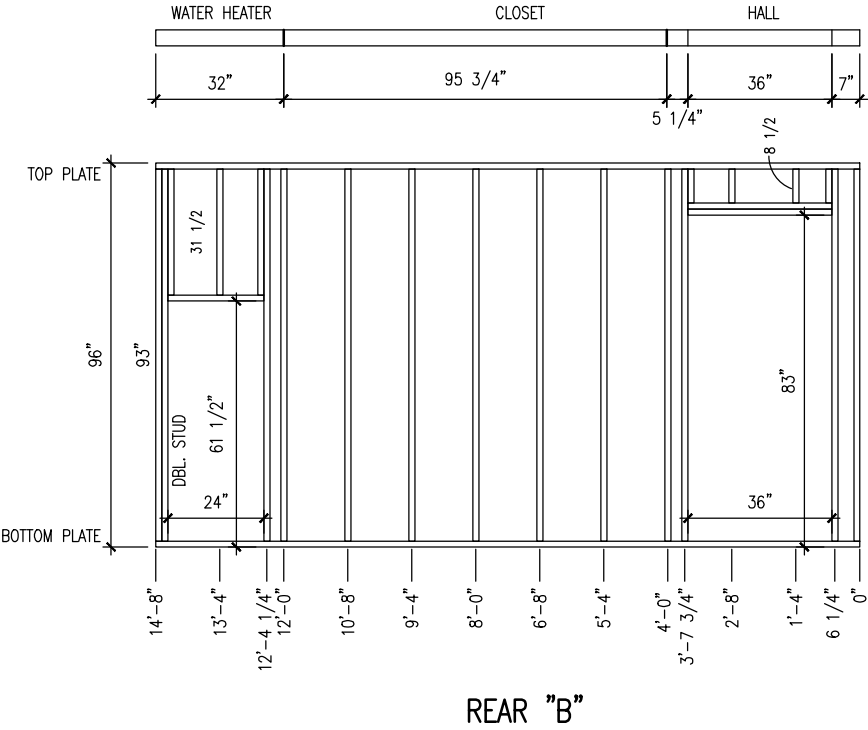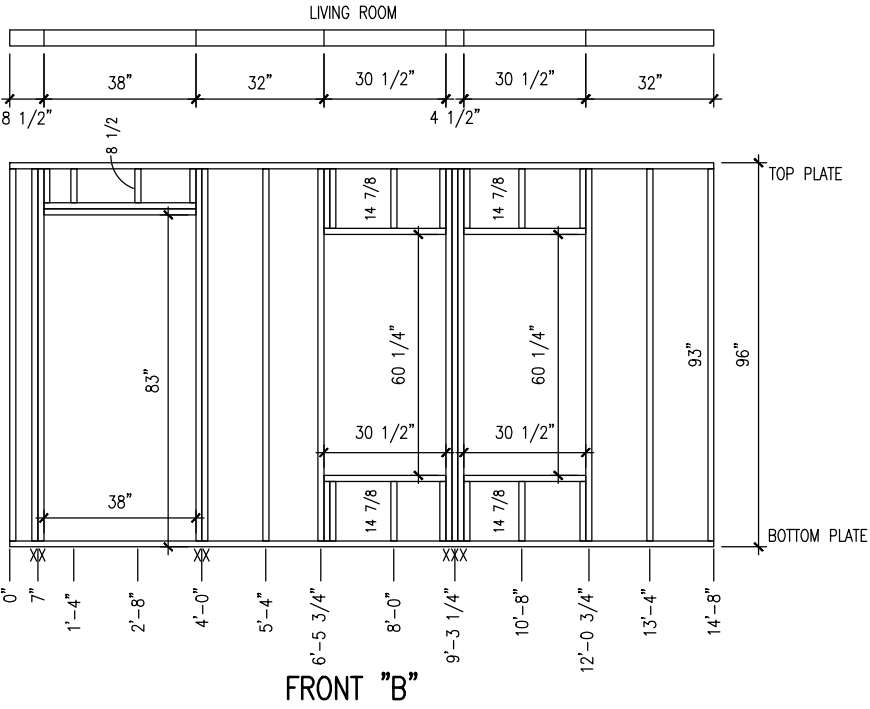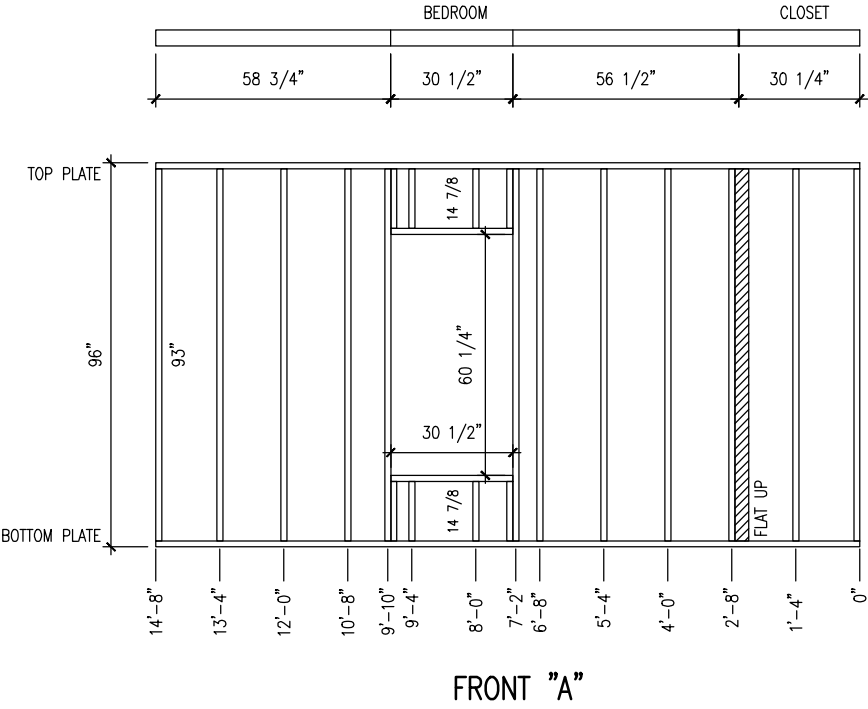

MODEL: MARATHON — 32443A
DWG: FP—32443A

DATE: 07/24/2026
SCALE: 1/4" = 1'-0"

TITLE:


REF # DESCRIPTION

END WALLS

DATE

REVISED BY:



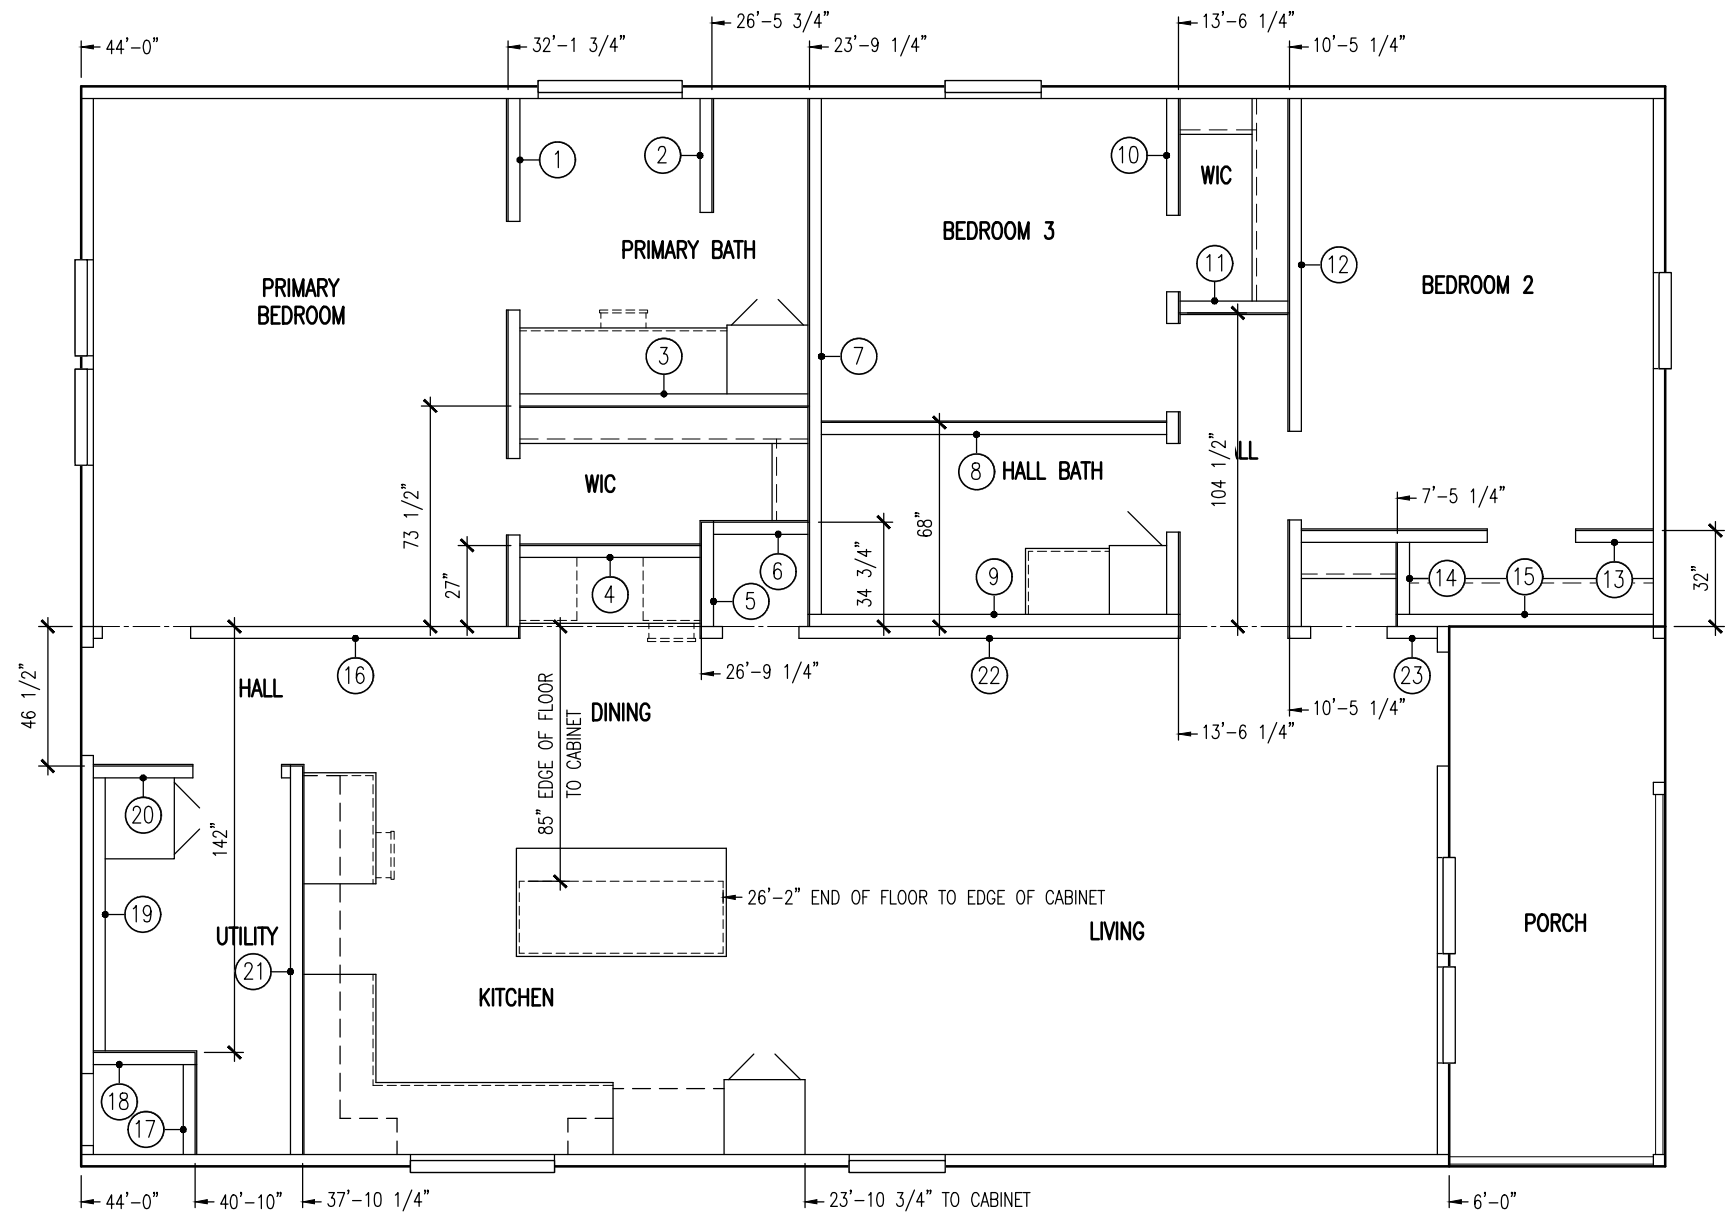

MODEL:
MARATHON – 32443A

DWG:
FP-32443A

DATE:
07/24/2026

SCALE:
3/16" = 1'-0"


TITLE:

WALLSET

REF #	DESCRIPTION
-	-

DATE	REVISED BY:
-	-



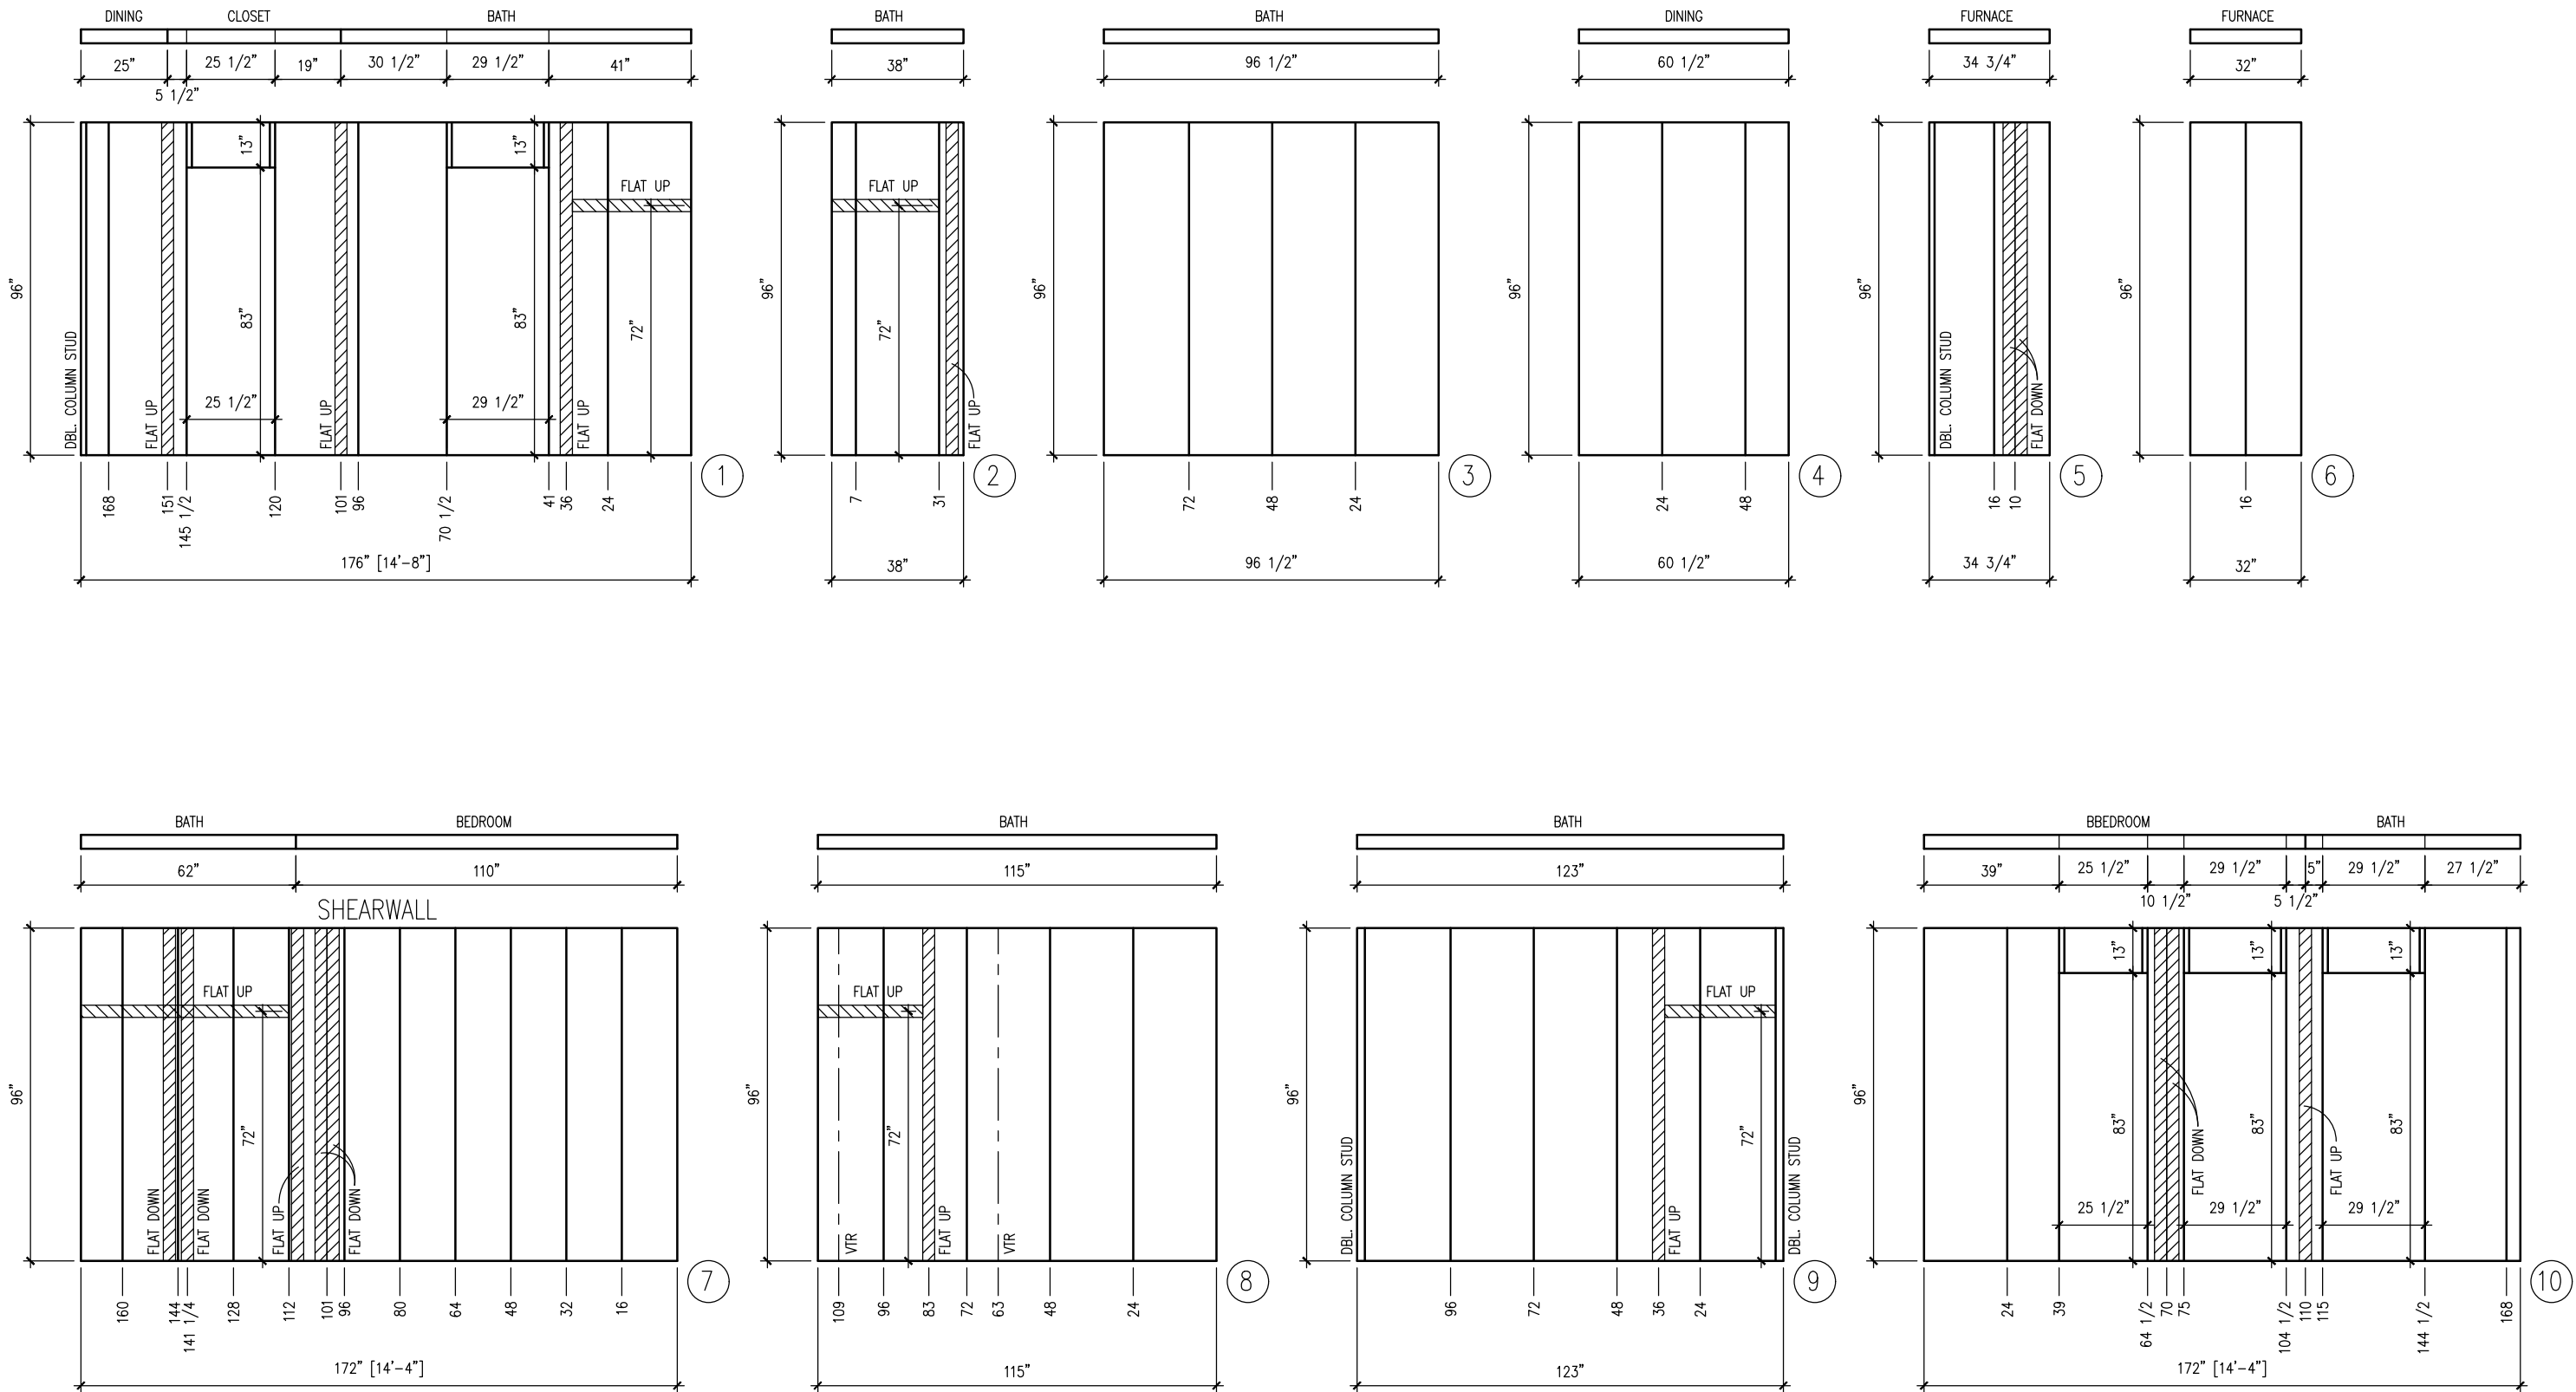

MODEL:
MARATHON — 32443A

DWG:
FP—32443A

DATE:
07/24/2026

SCALE:
1/4" = 1'-0"


TITLE:

REF #	DESCRIPTION
-	-

PARTITIONS PAGE 1 OF 3

DATE	REVISED BY:
-	-



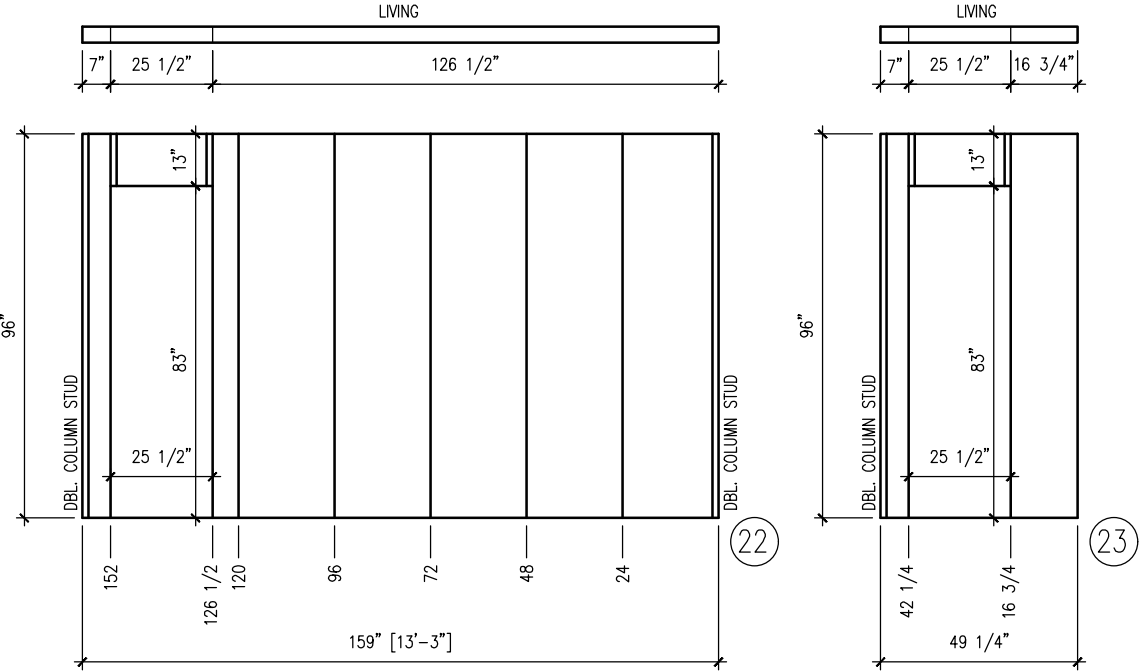

MODEL:
MARATHON — 32443A

DWG:
FP—32443A


DATE:
07/25/2026

SCALE:
1/4" = 1'-0"

TITLE:
PARTITIONS PAGE 3 OF 3

REF #	DESCRIPTION	DATE	REVISED BY:



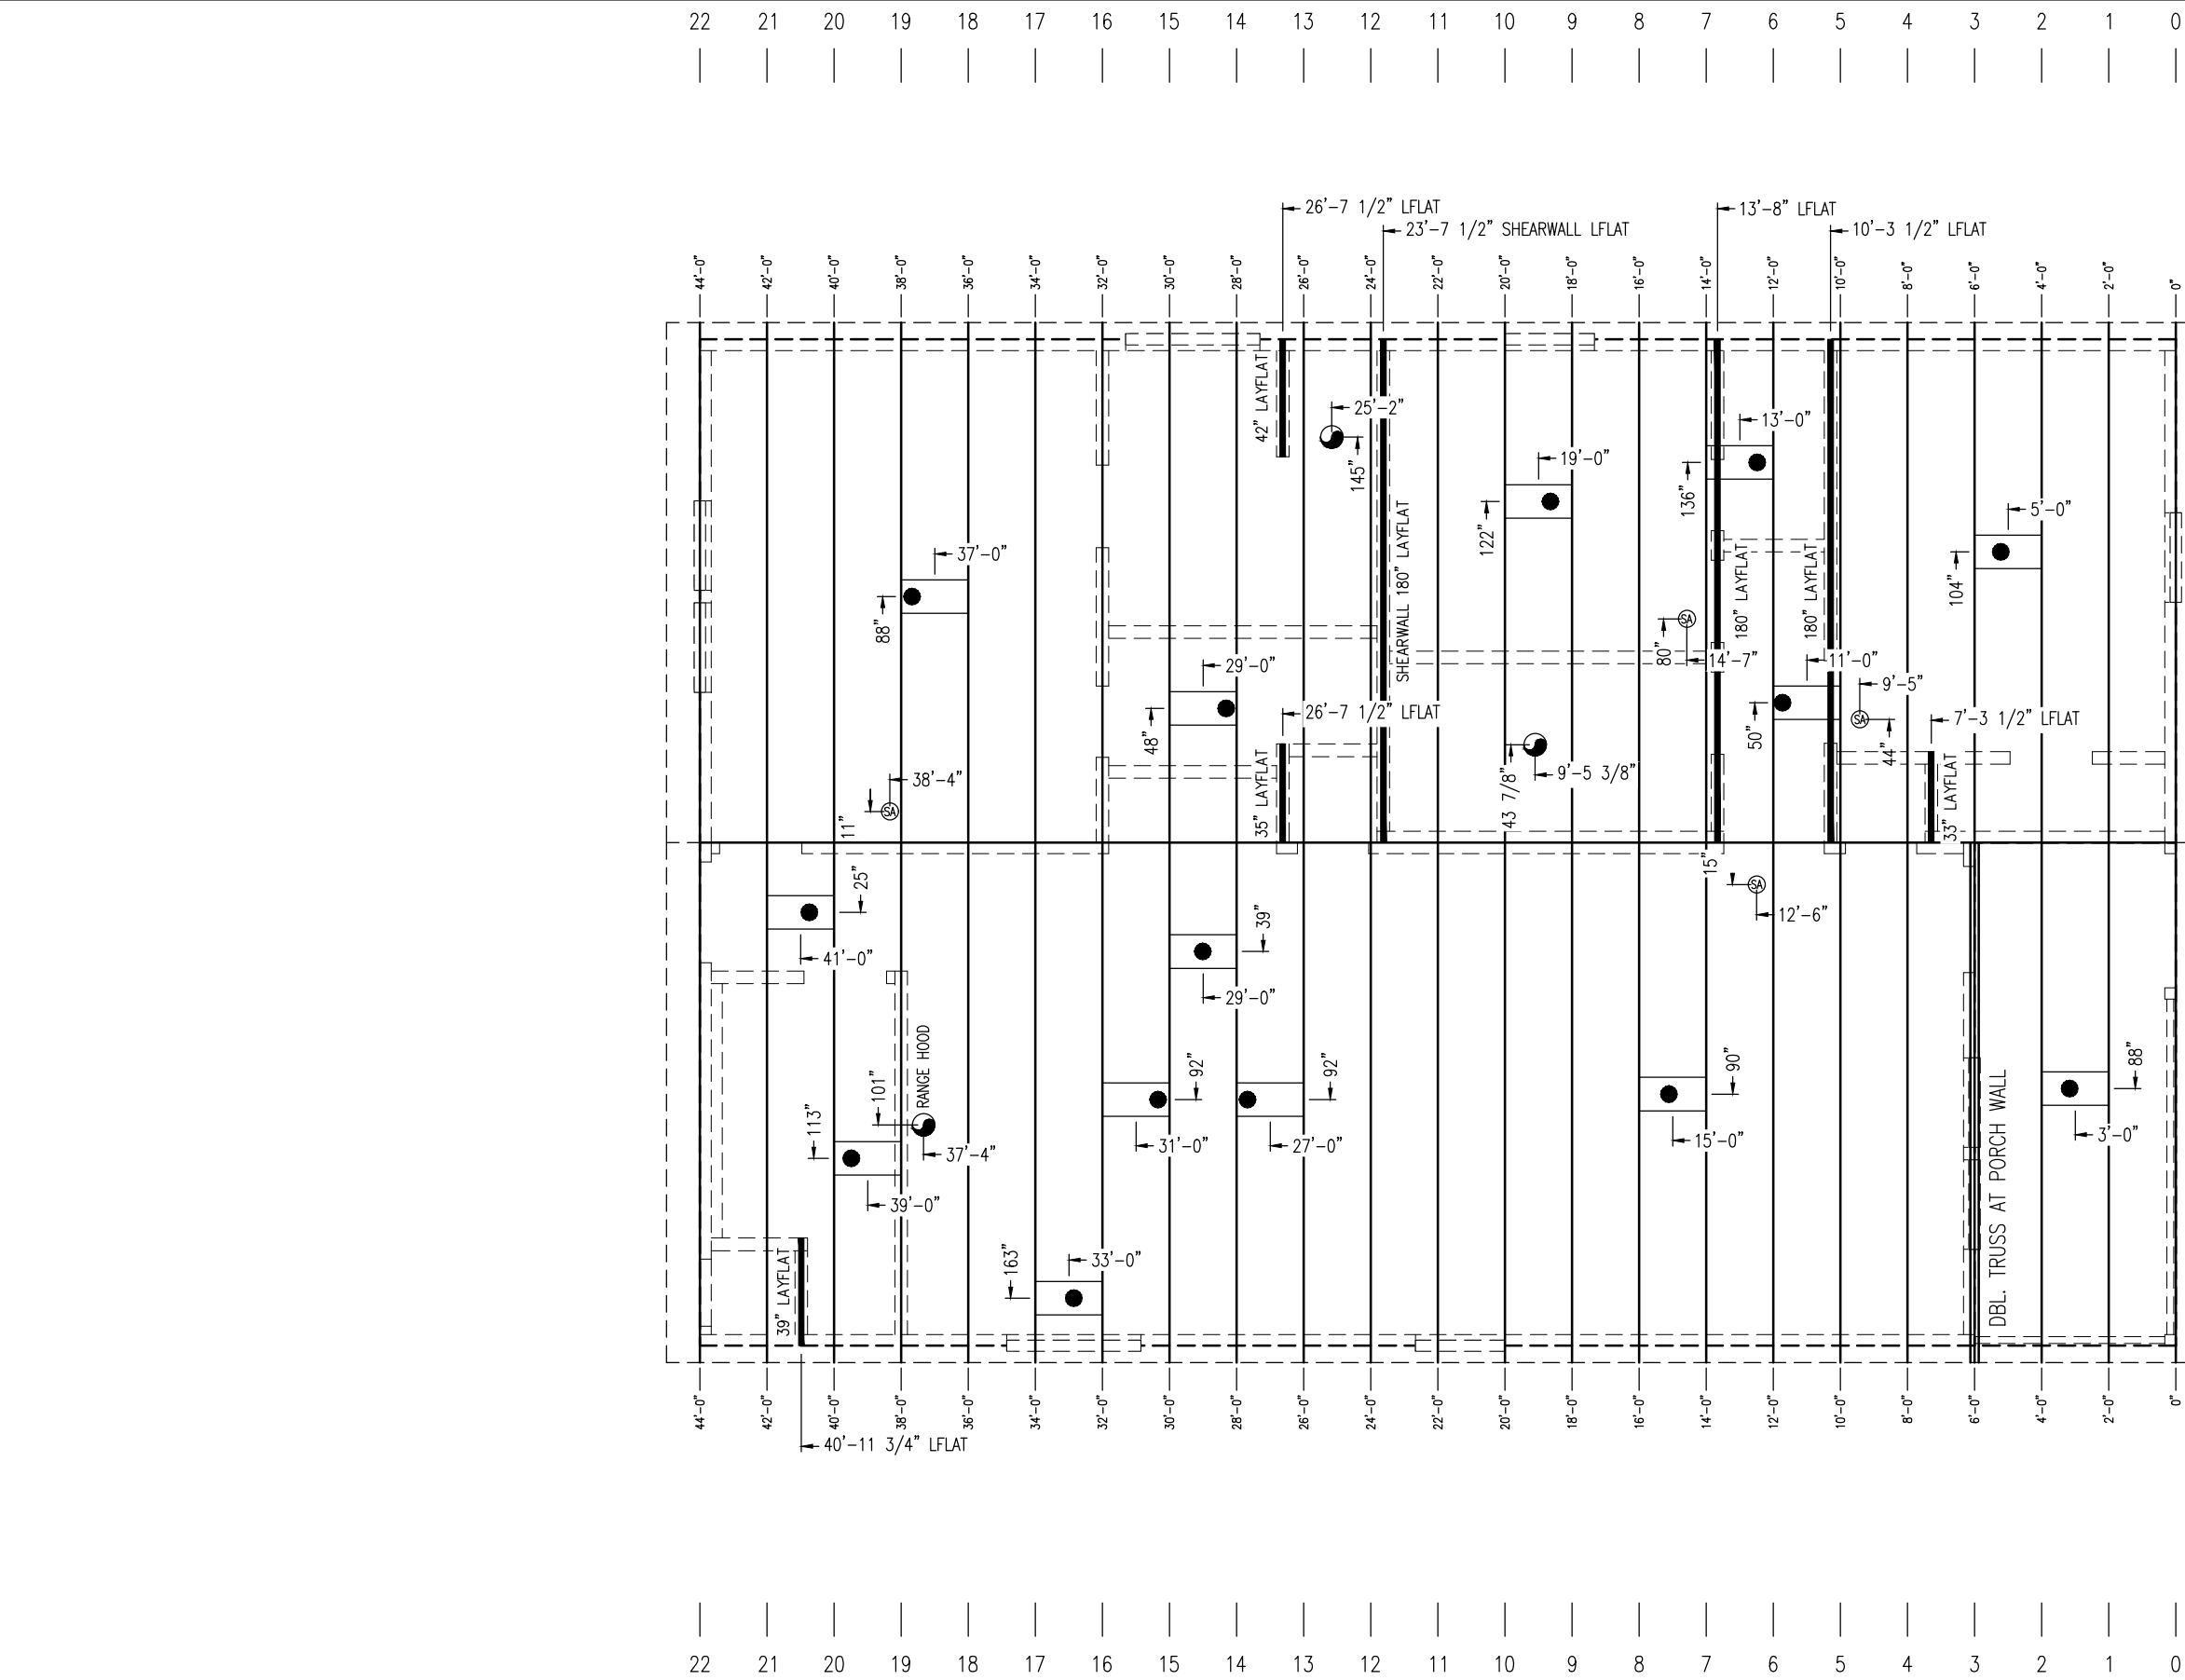

ROOF LEGEND


- - LIGHT BACKER
- ⊙ - EXHAUST FAN
- ⊕ - SMOKE ALARM
- ⊖ - RECESSED LIGHT



MODEL: MARATHON – 32443A
DWG: FP–32443A

DATE: 07/27/2026
SCALE: 3/16" = 1'-0"

TITLE:		ROOF FRAMING	
REF #	DESCRIPTION	DATE	REVISED BY:
-	-	-	-




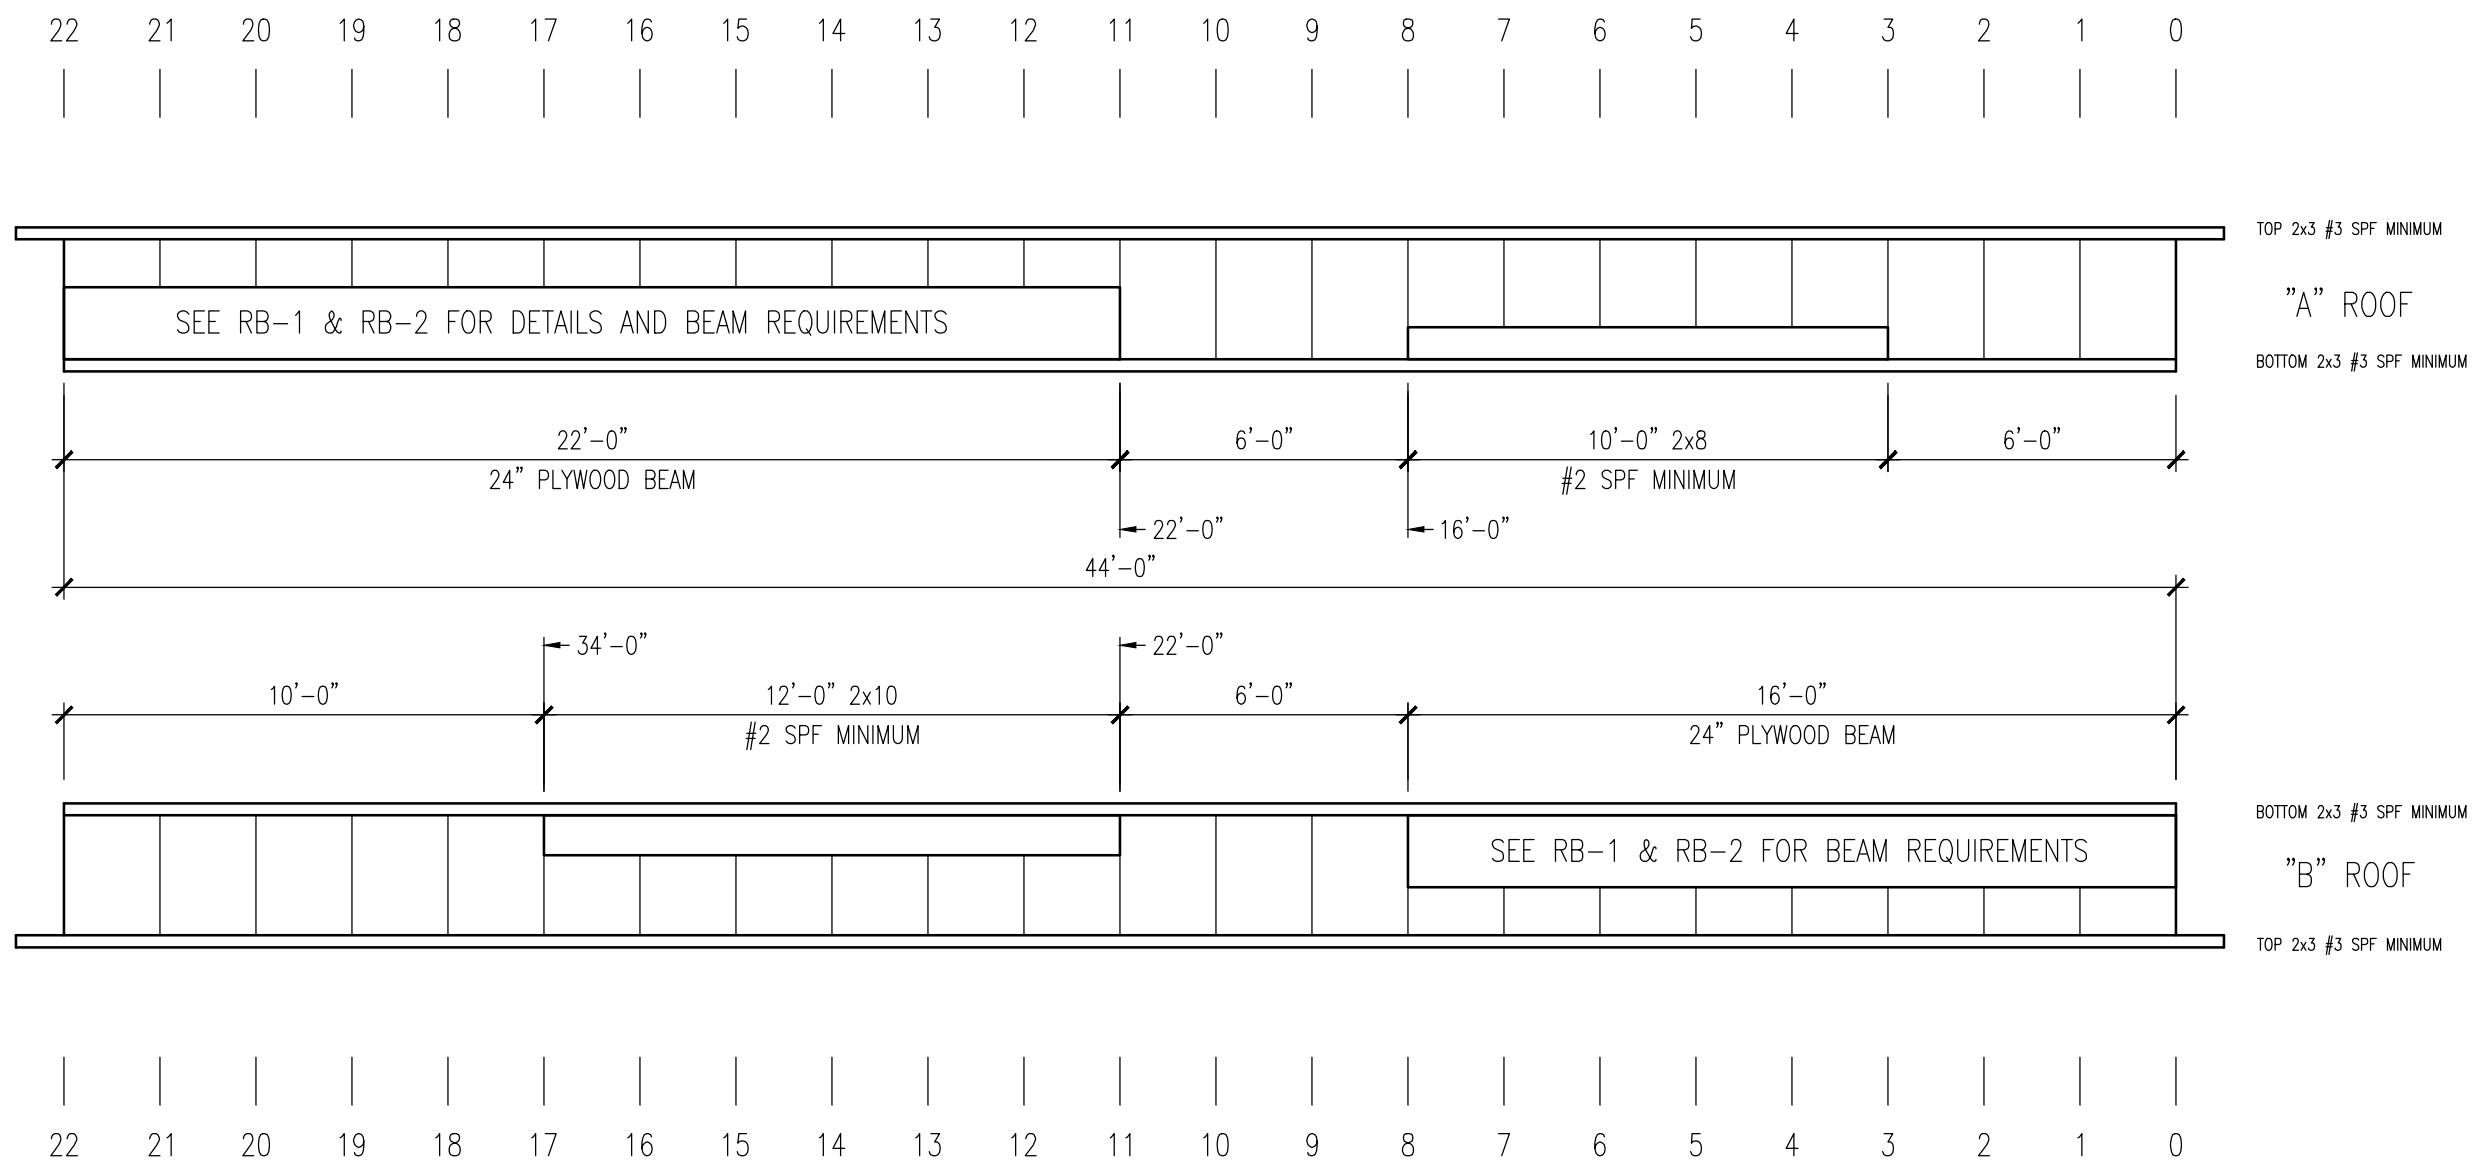

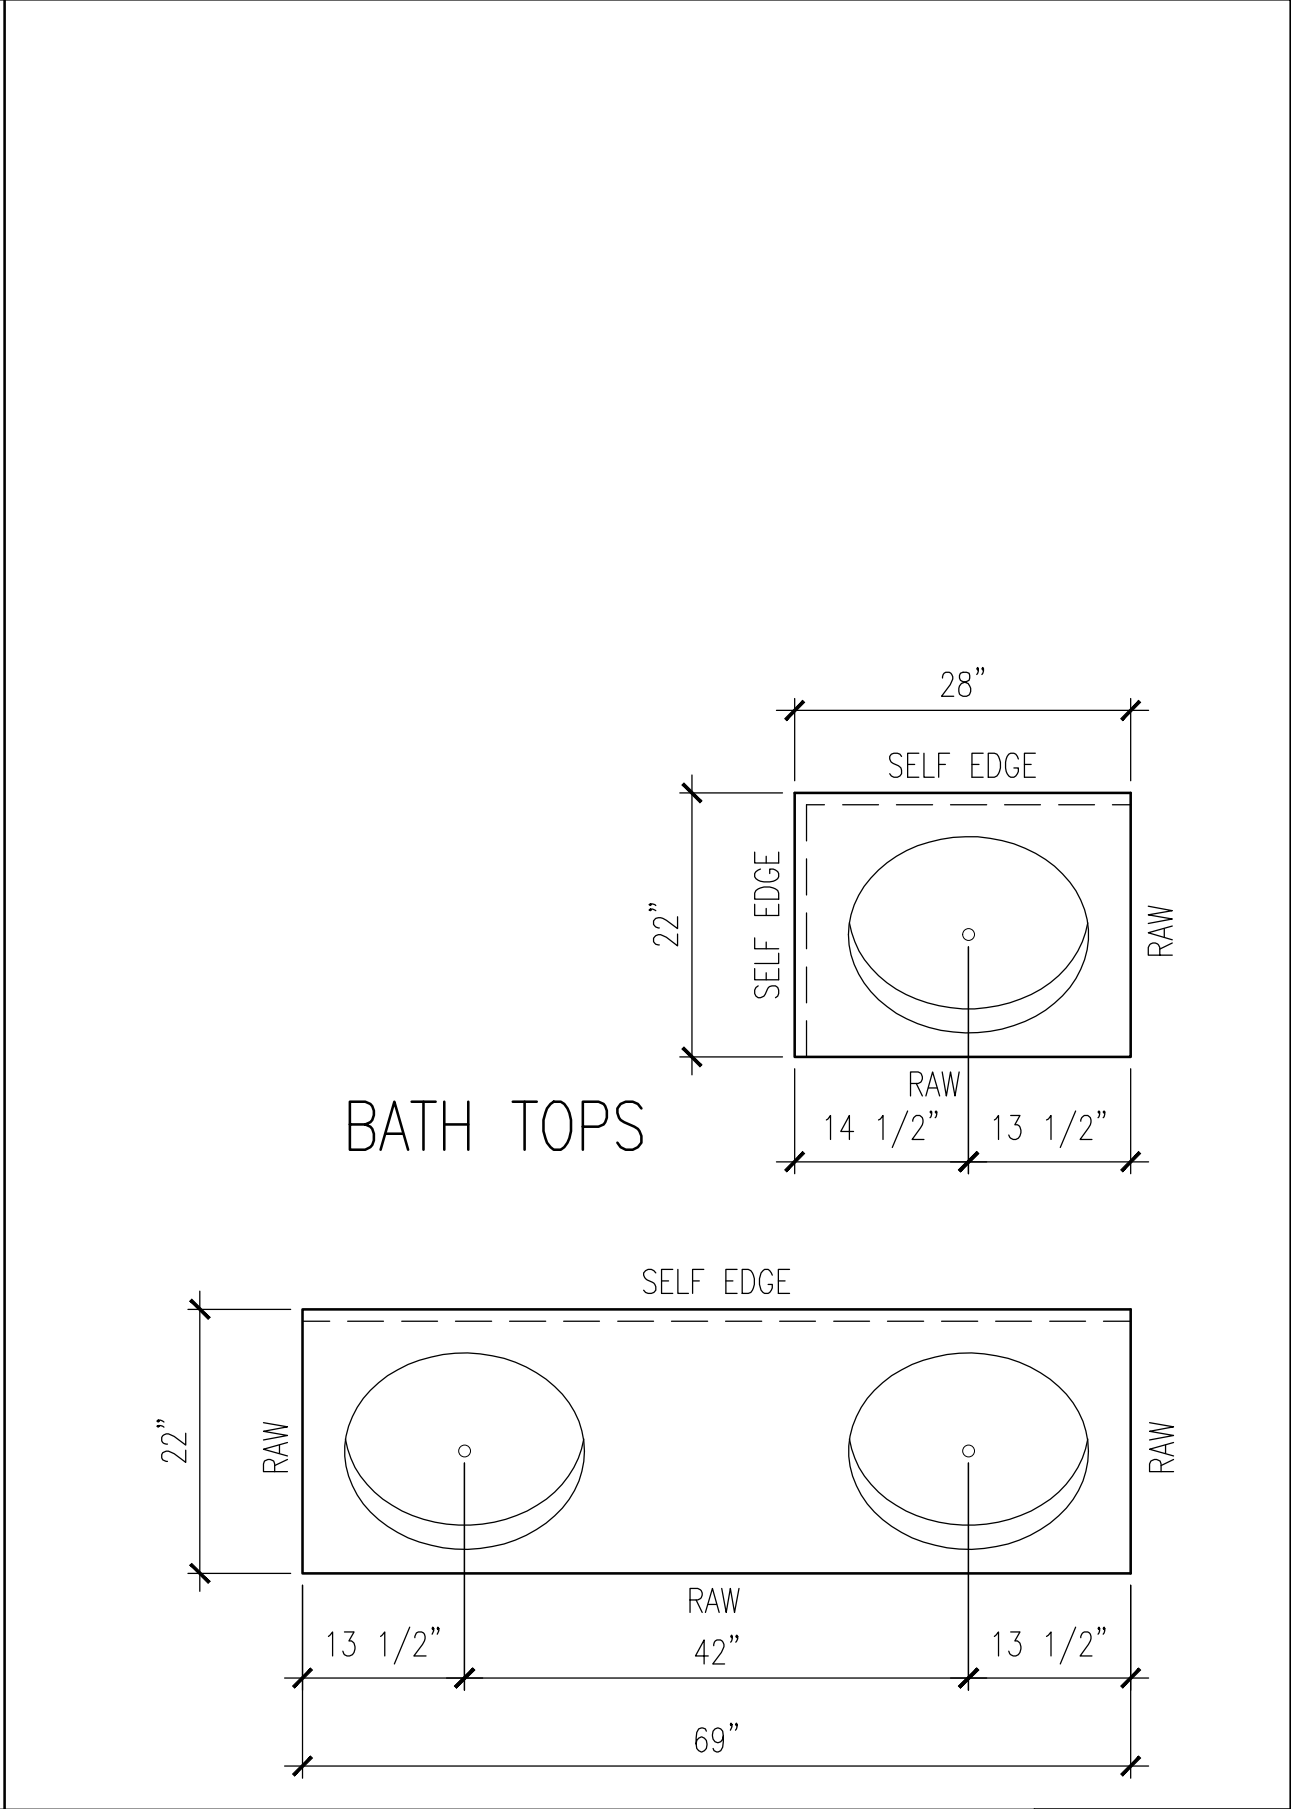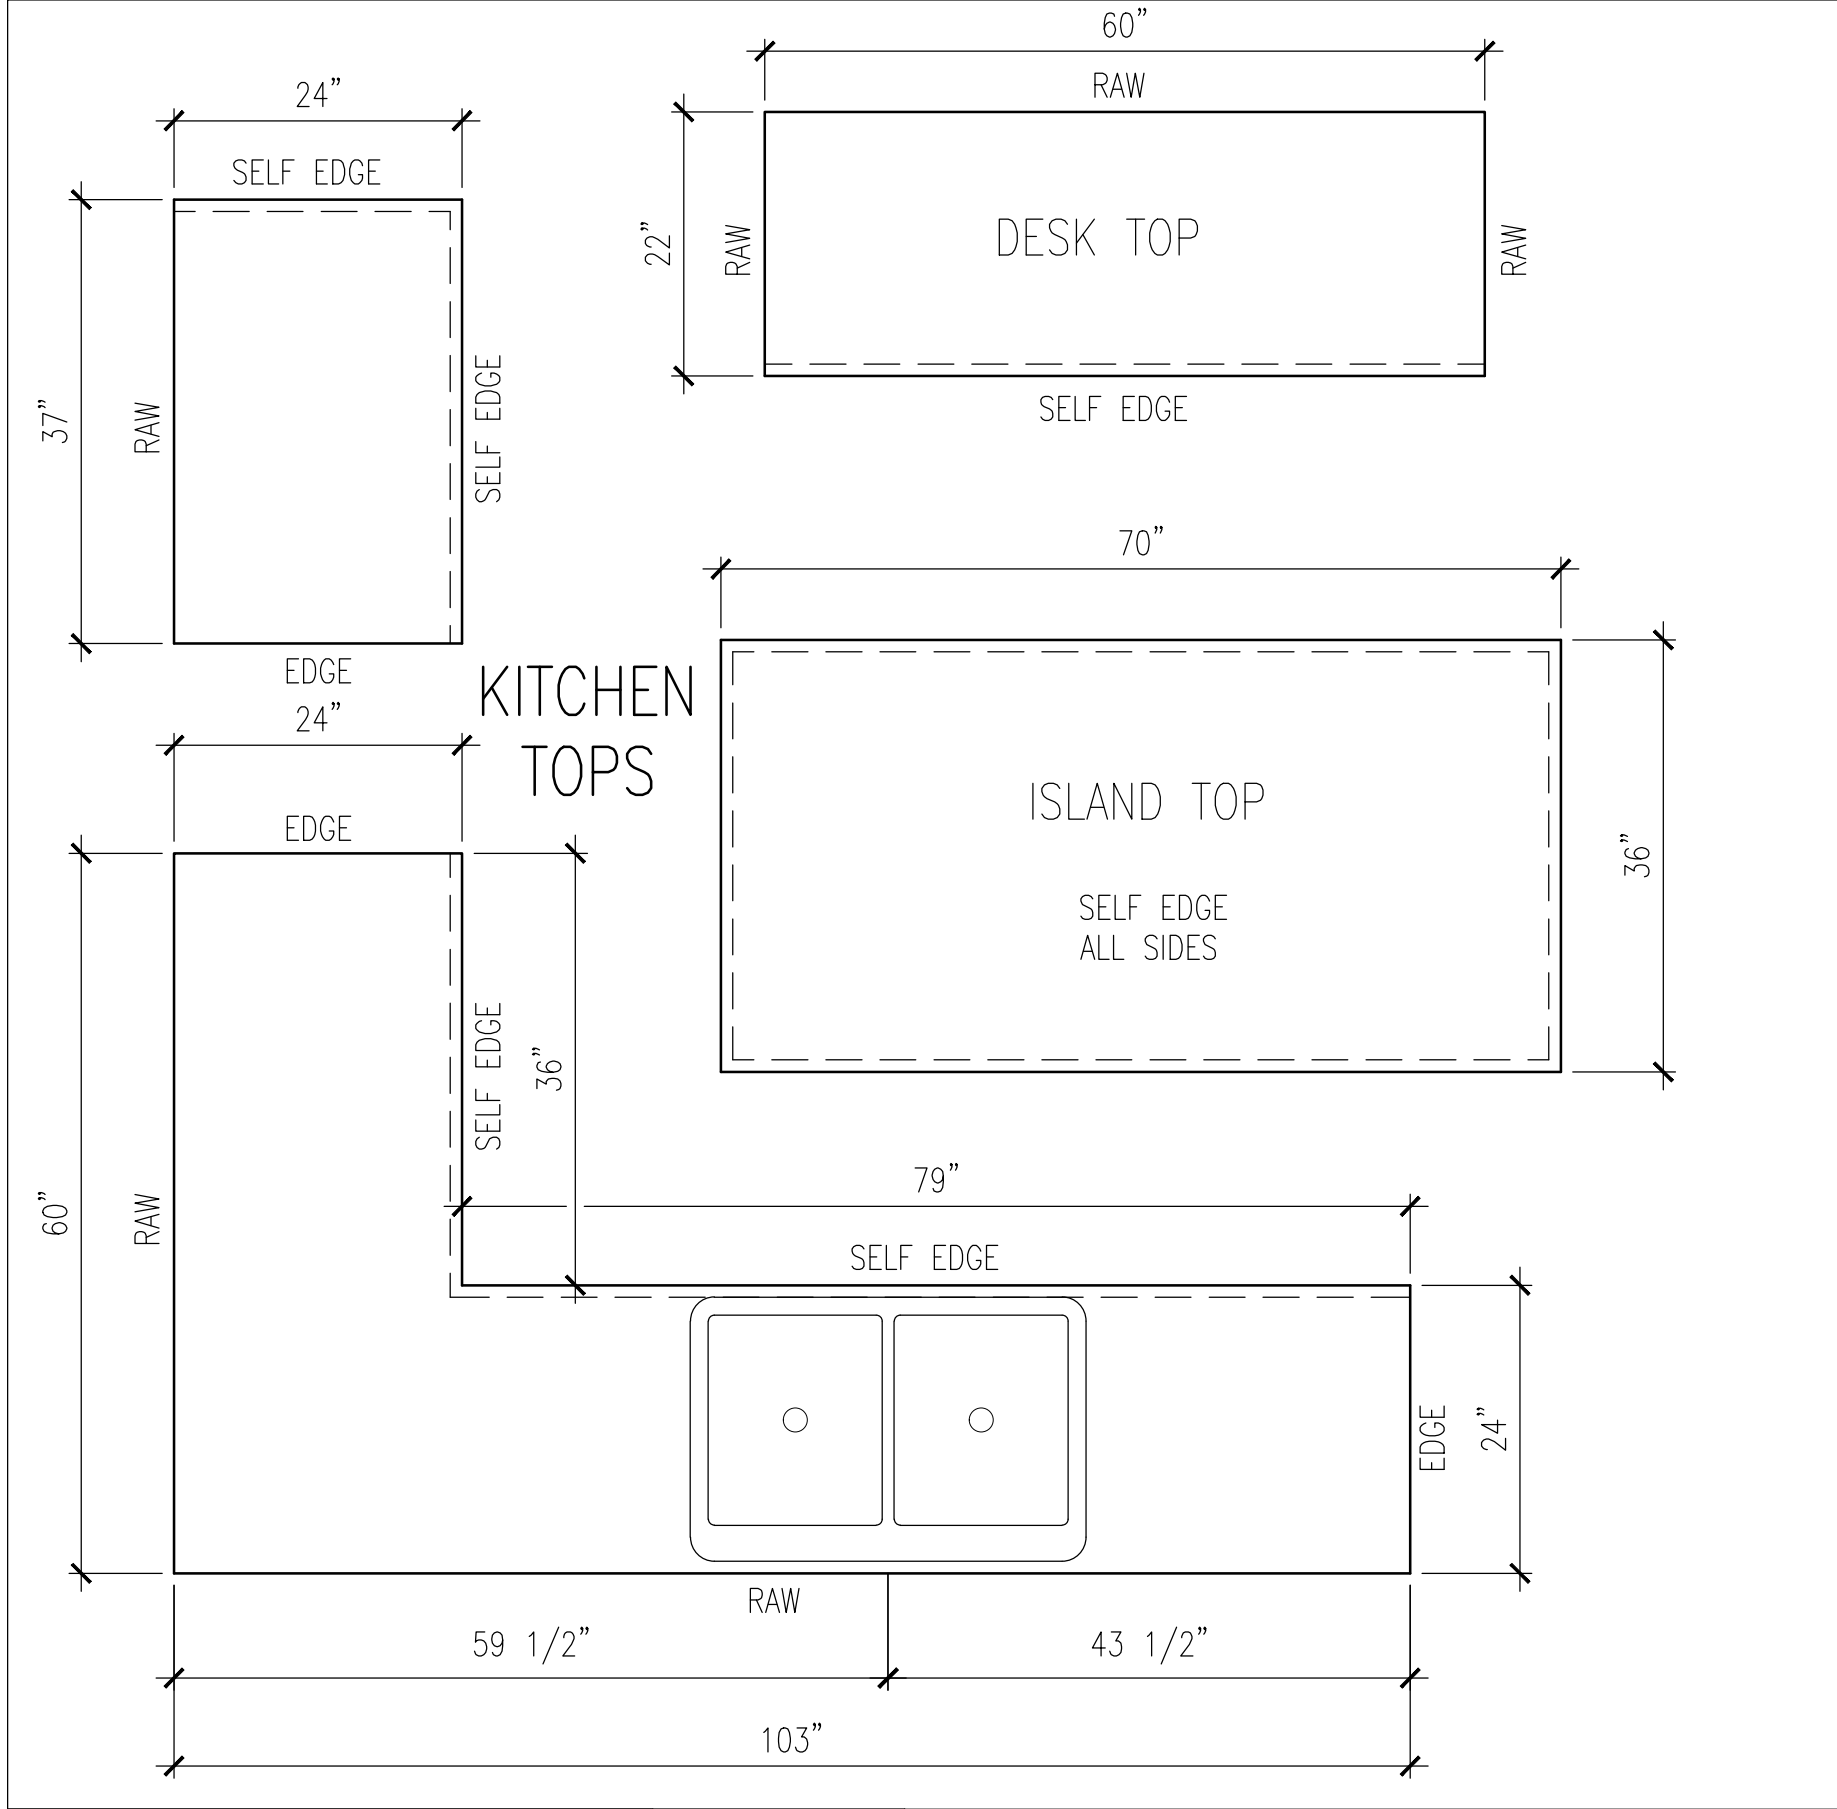


MODEL: MARATHON – 32443A		DATE: 07/27/2026	TITLE: COUNTER TOPS			
DWG: FP–32443A		SCALE: 3/4" = 1'–0"	REF #	DESCRIPTION	DATE	REVISED BY:
			-	-	-	-




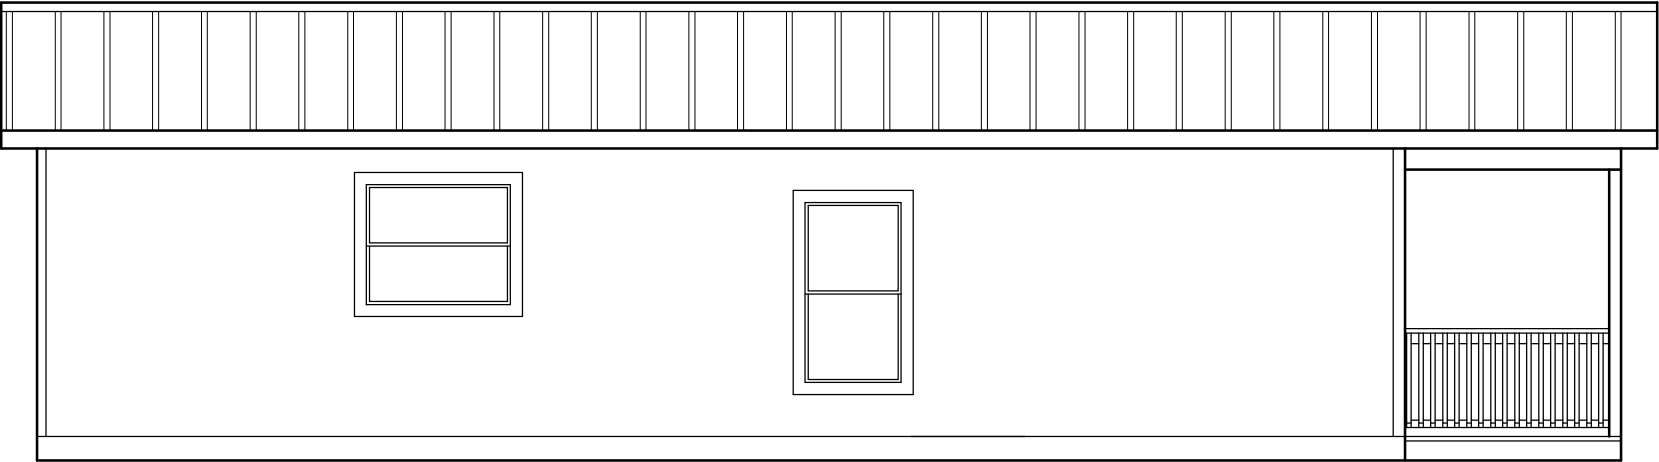


FRONT SIDE

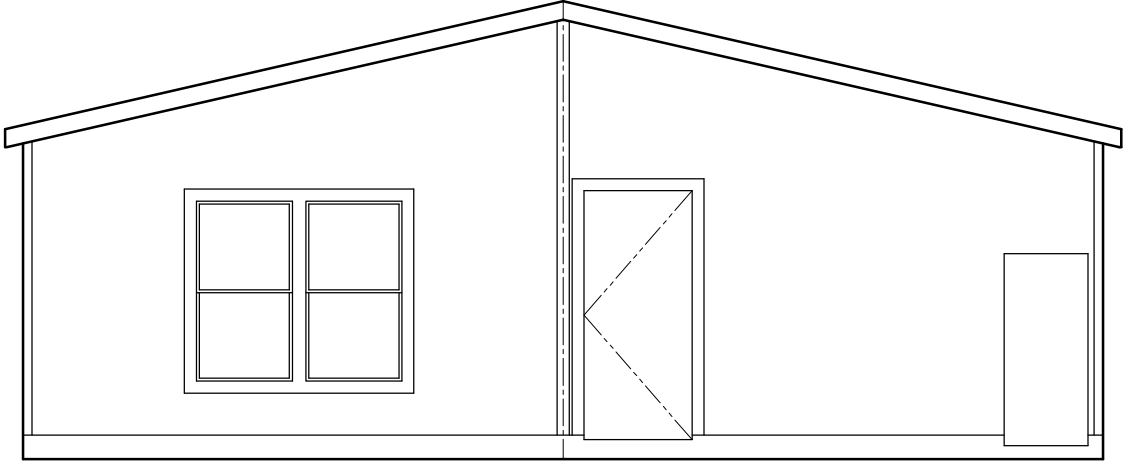

LEFT SIDE

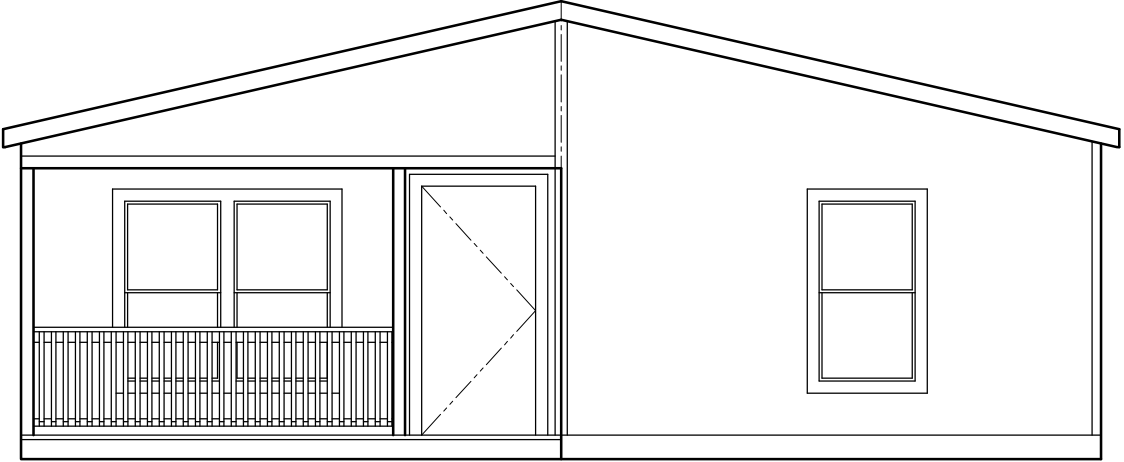

RIGHT SIDE (HITCH END)

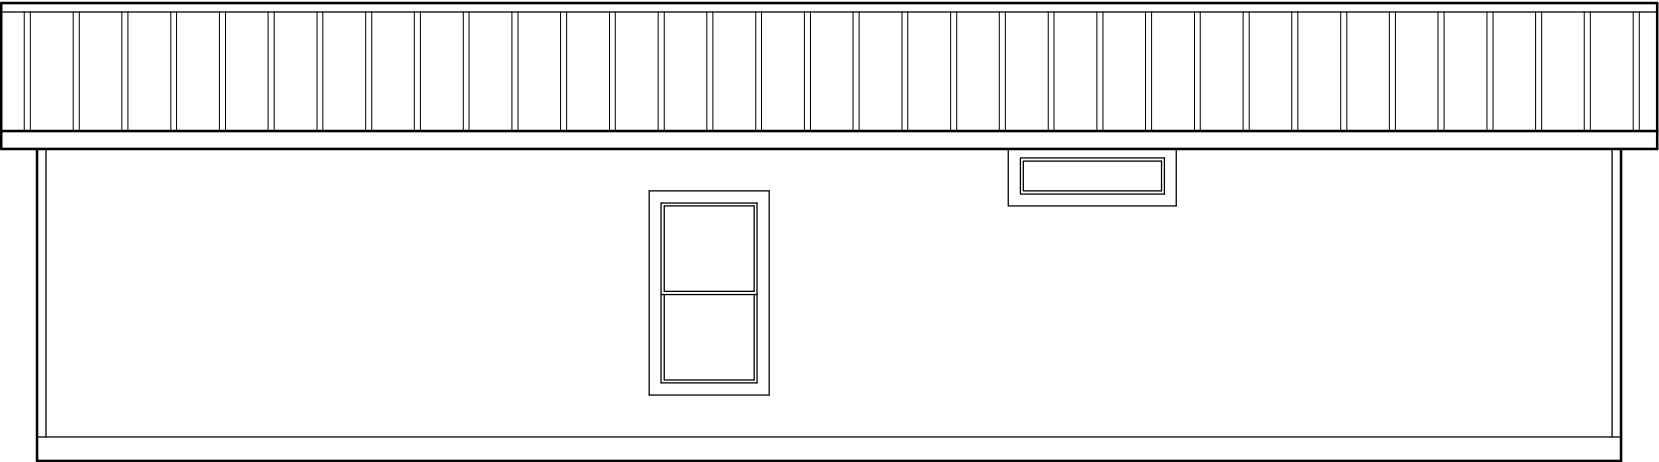

BACK SIDE

MODEL:
MARATHON — 32443A

DWG:
FP—32443A

DATE:
07/27/2026

SCALE:
3/16" = 1'-0"


TITLE:

EXTERIOR ELEVATIONS

REF #	DESCRIPTION
-	-

DATE	REVISED BY:
-	-



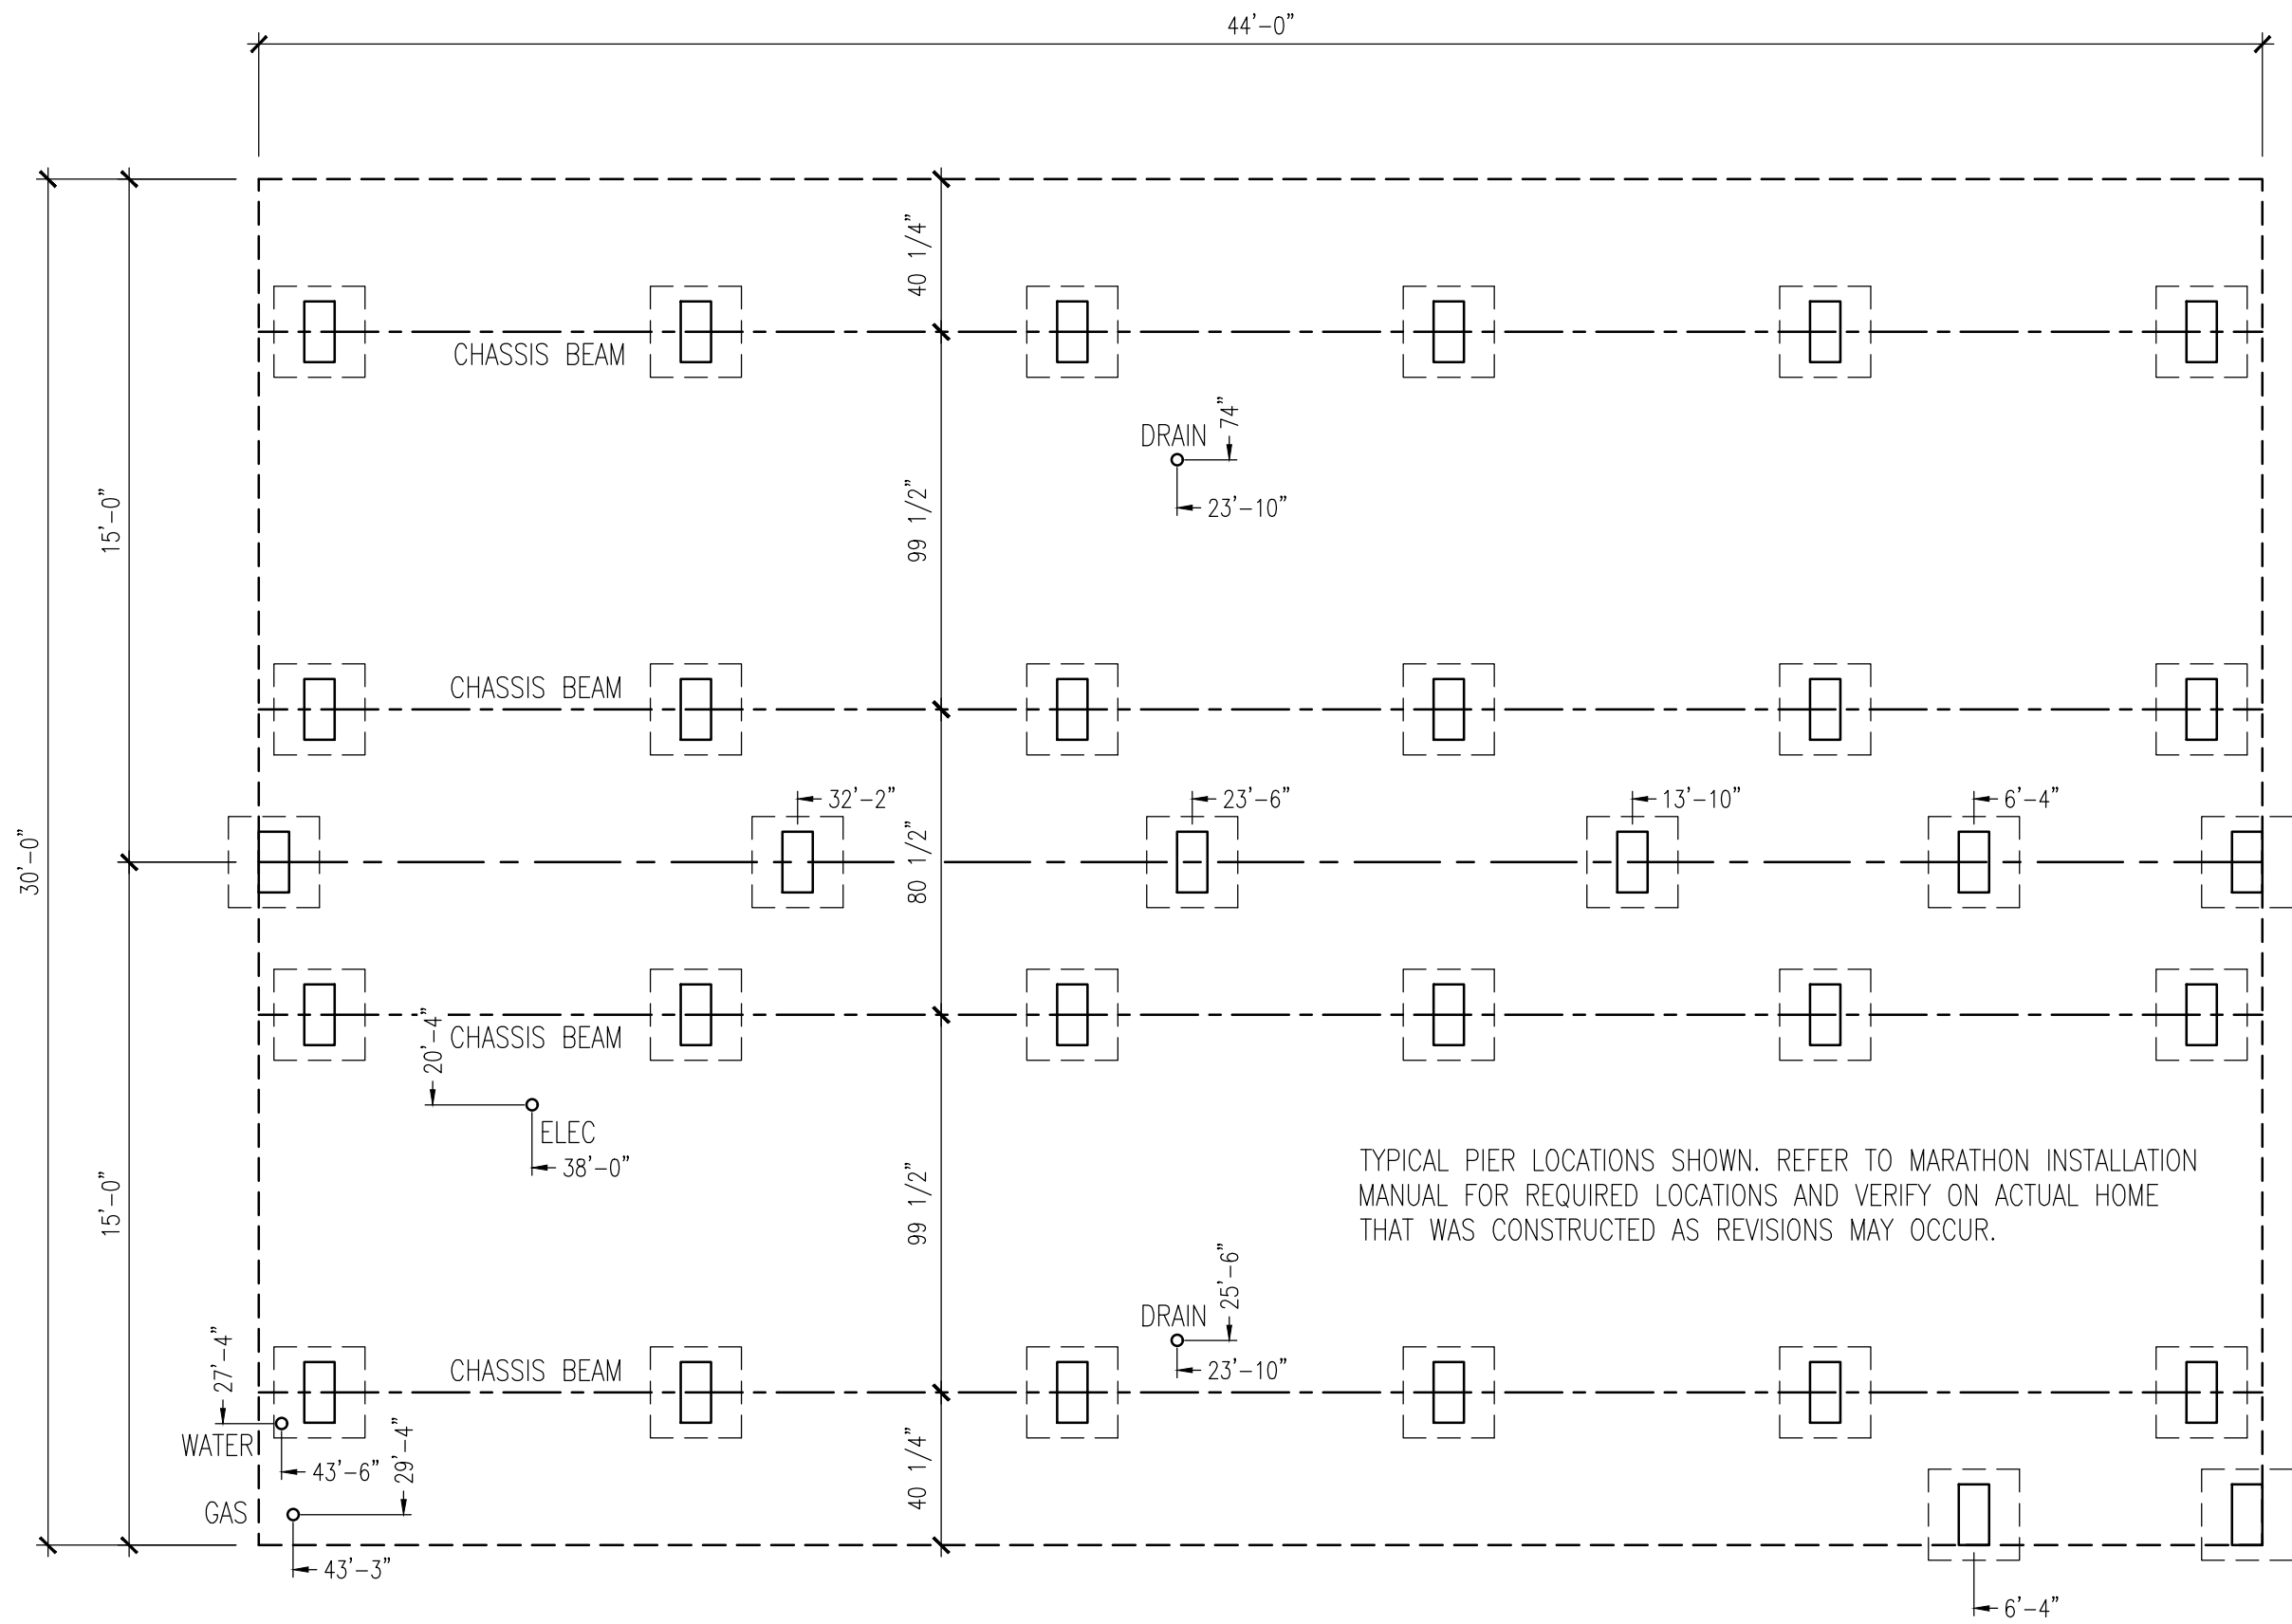

MODEL:
MARATHON — 32443A

DWG:
FP-32443A

DATE:
07/27/2026

SCALE:
1/4" = 1'-0"

TITLE:	
UTILITY DROPS & TYPICAL PIER LOCATIONS	
REF #	DESCRIPTION
-	-

DATE	REVISED BY:
-	-

